


PHILIPPINE PAVILION

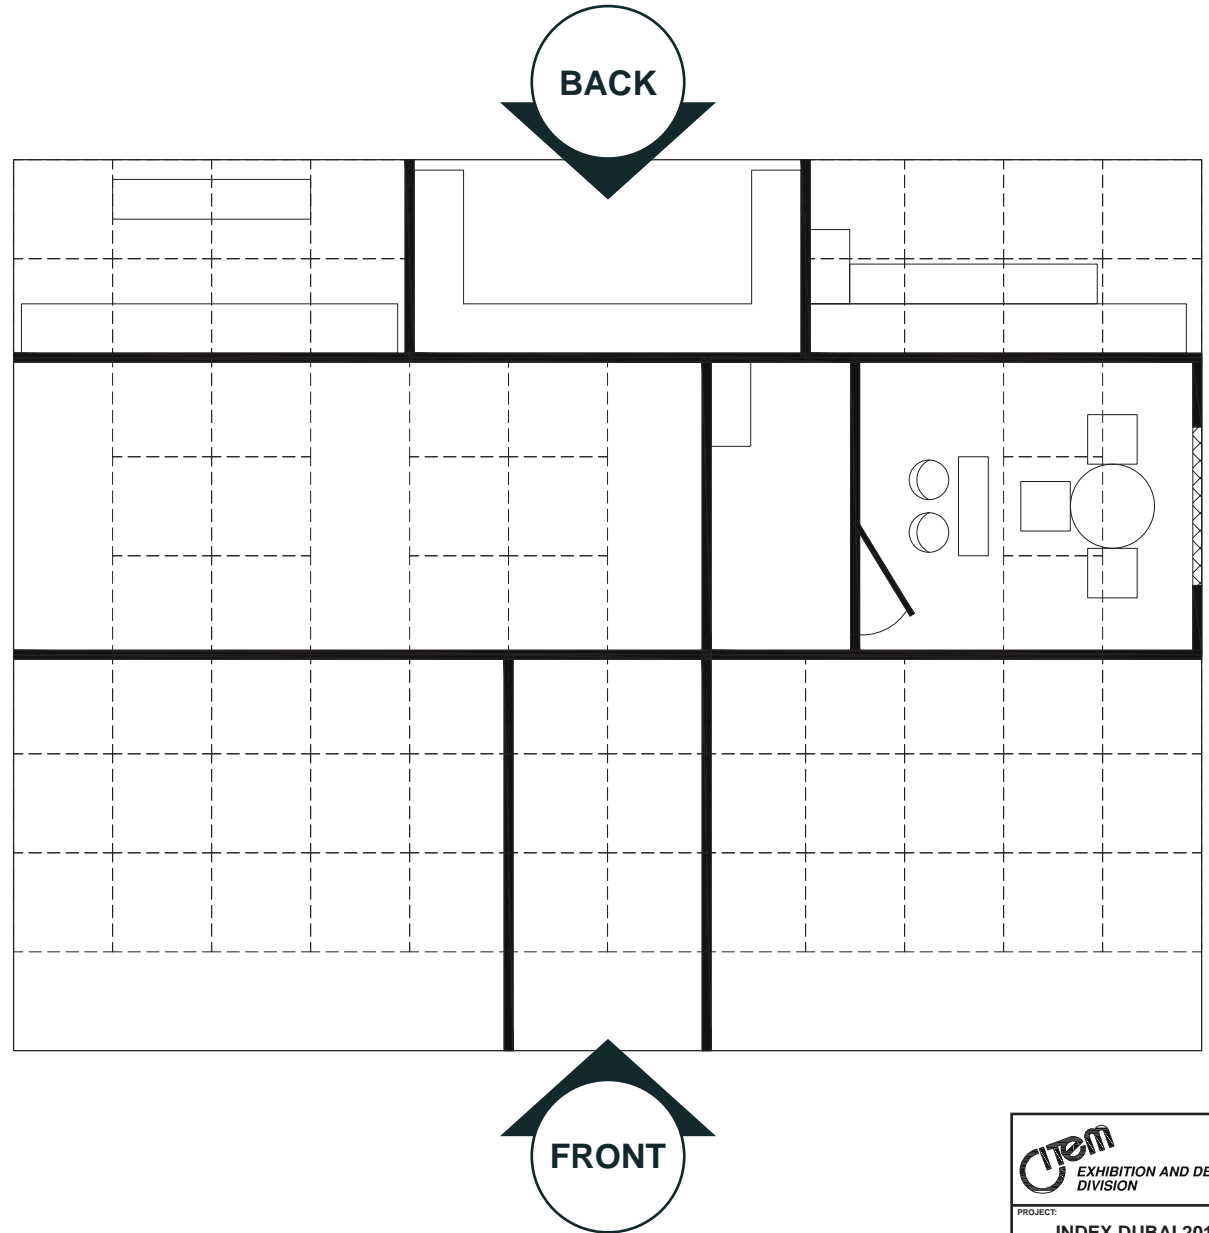

 EXHIBITION AND DESIGN DIVISION		
PROJECT: INDEX DUBAI 2019		
TITLE: PHILIPPINES PAVILION		
LOCATION: DWTC, UAE		
CONTENT: DETAILS	DESIGNER: MIR	
DATE: 08/22/2019	REVISION: 01	SHEET NO: 2

PERSPECTIVE
PHILIPPINES PAVILION




		
PROJECT: INDEX DUBAI 2019		
TITLE: PHILIPPINES PAVILION		
LOCATION: DWTC, UAE		
CONTENT:	DETAILS	DESIGNER: MIR
DATE: 08/22/2019	REVISION: 01	SHEET NO: 3

CARPET SCHEDULE


PHILIPPINES PAVILION

NOTE: CEILING GRID ARE NOT SHOWN FOR CLARITY

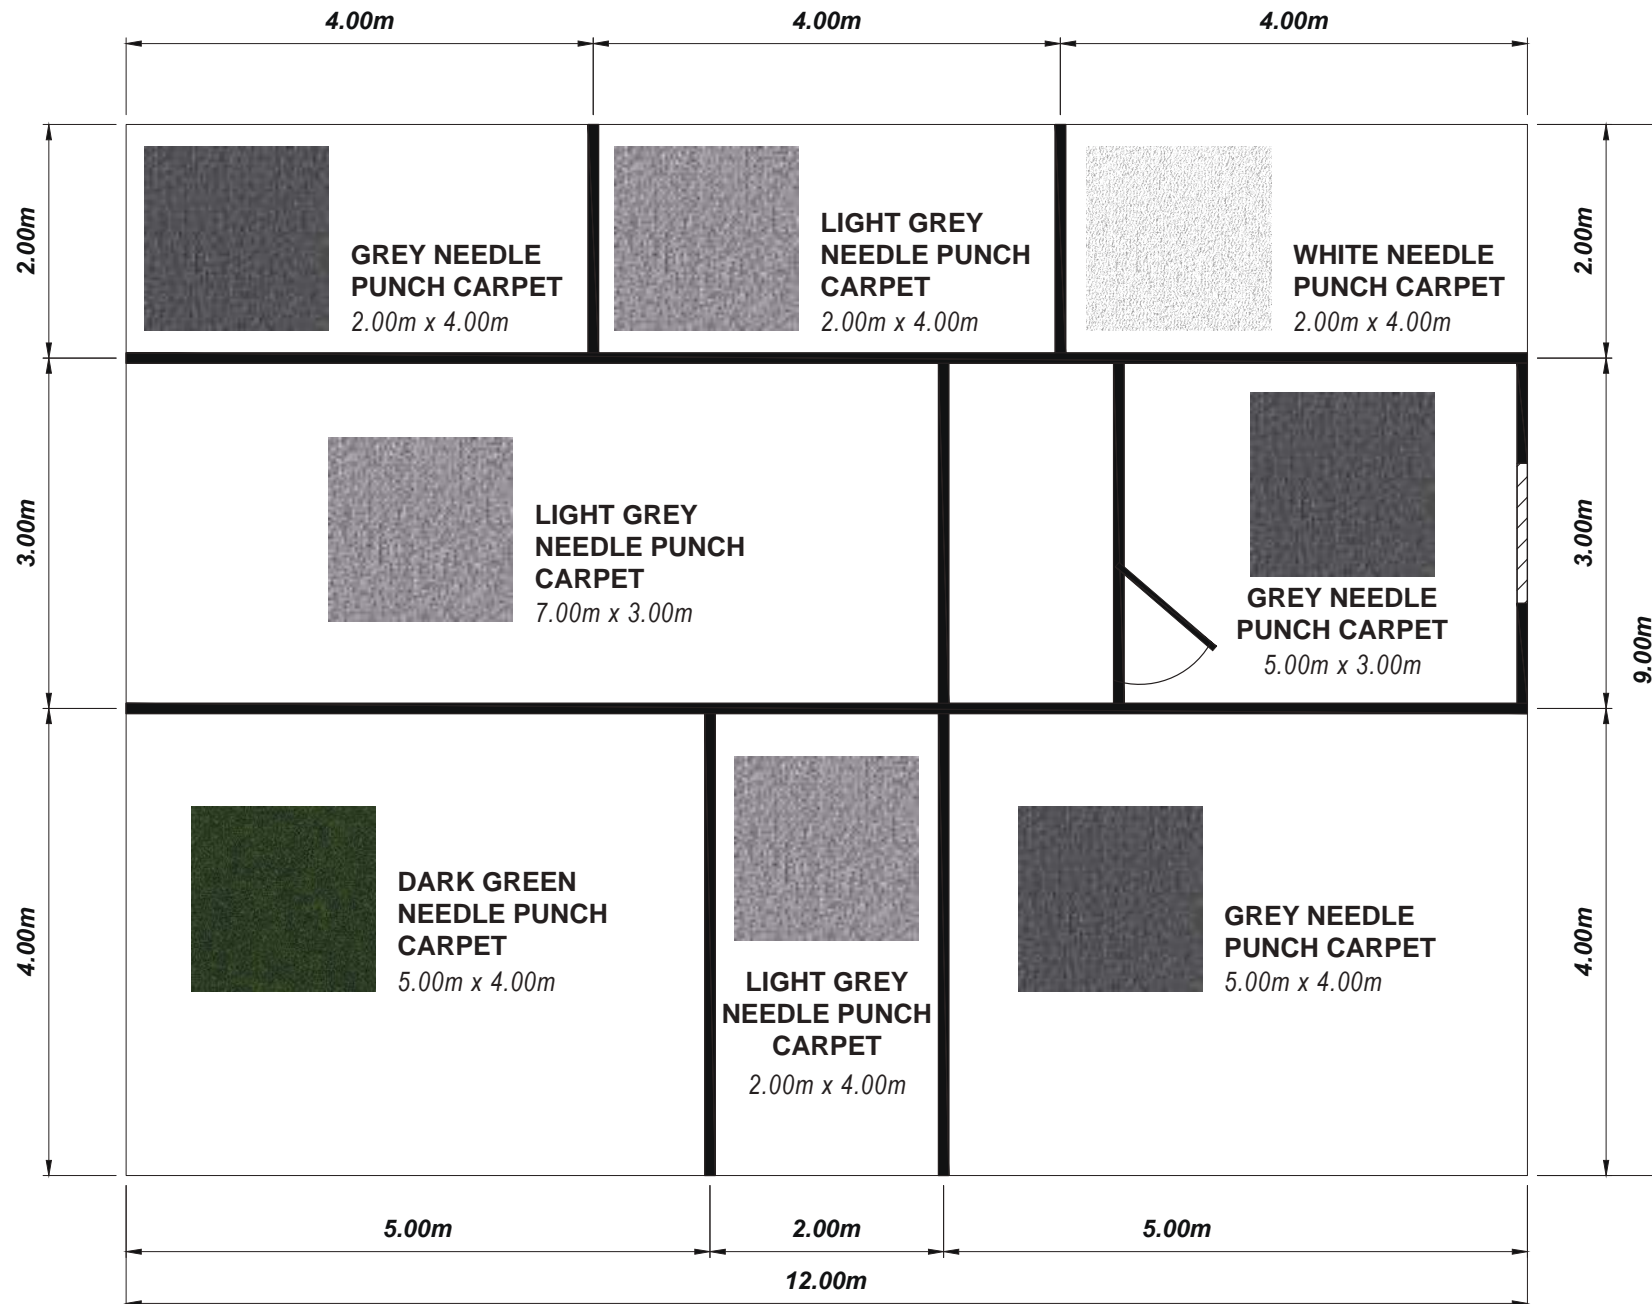

TITLE: PHILIPPINES PAVILION		
LOCATION: DWTC, UAE		
CONTENT:	DESIGNER:	
DETAILS	MIR	
DATE:	REVISION:	SHEET NO:
08/22/2019	01	4

FLOOR PLAN
PHILIPPINES PAVILION

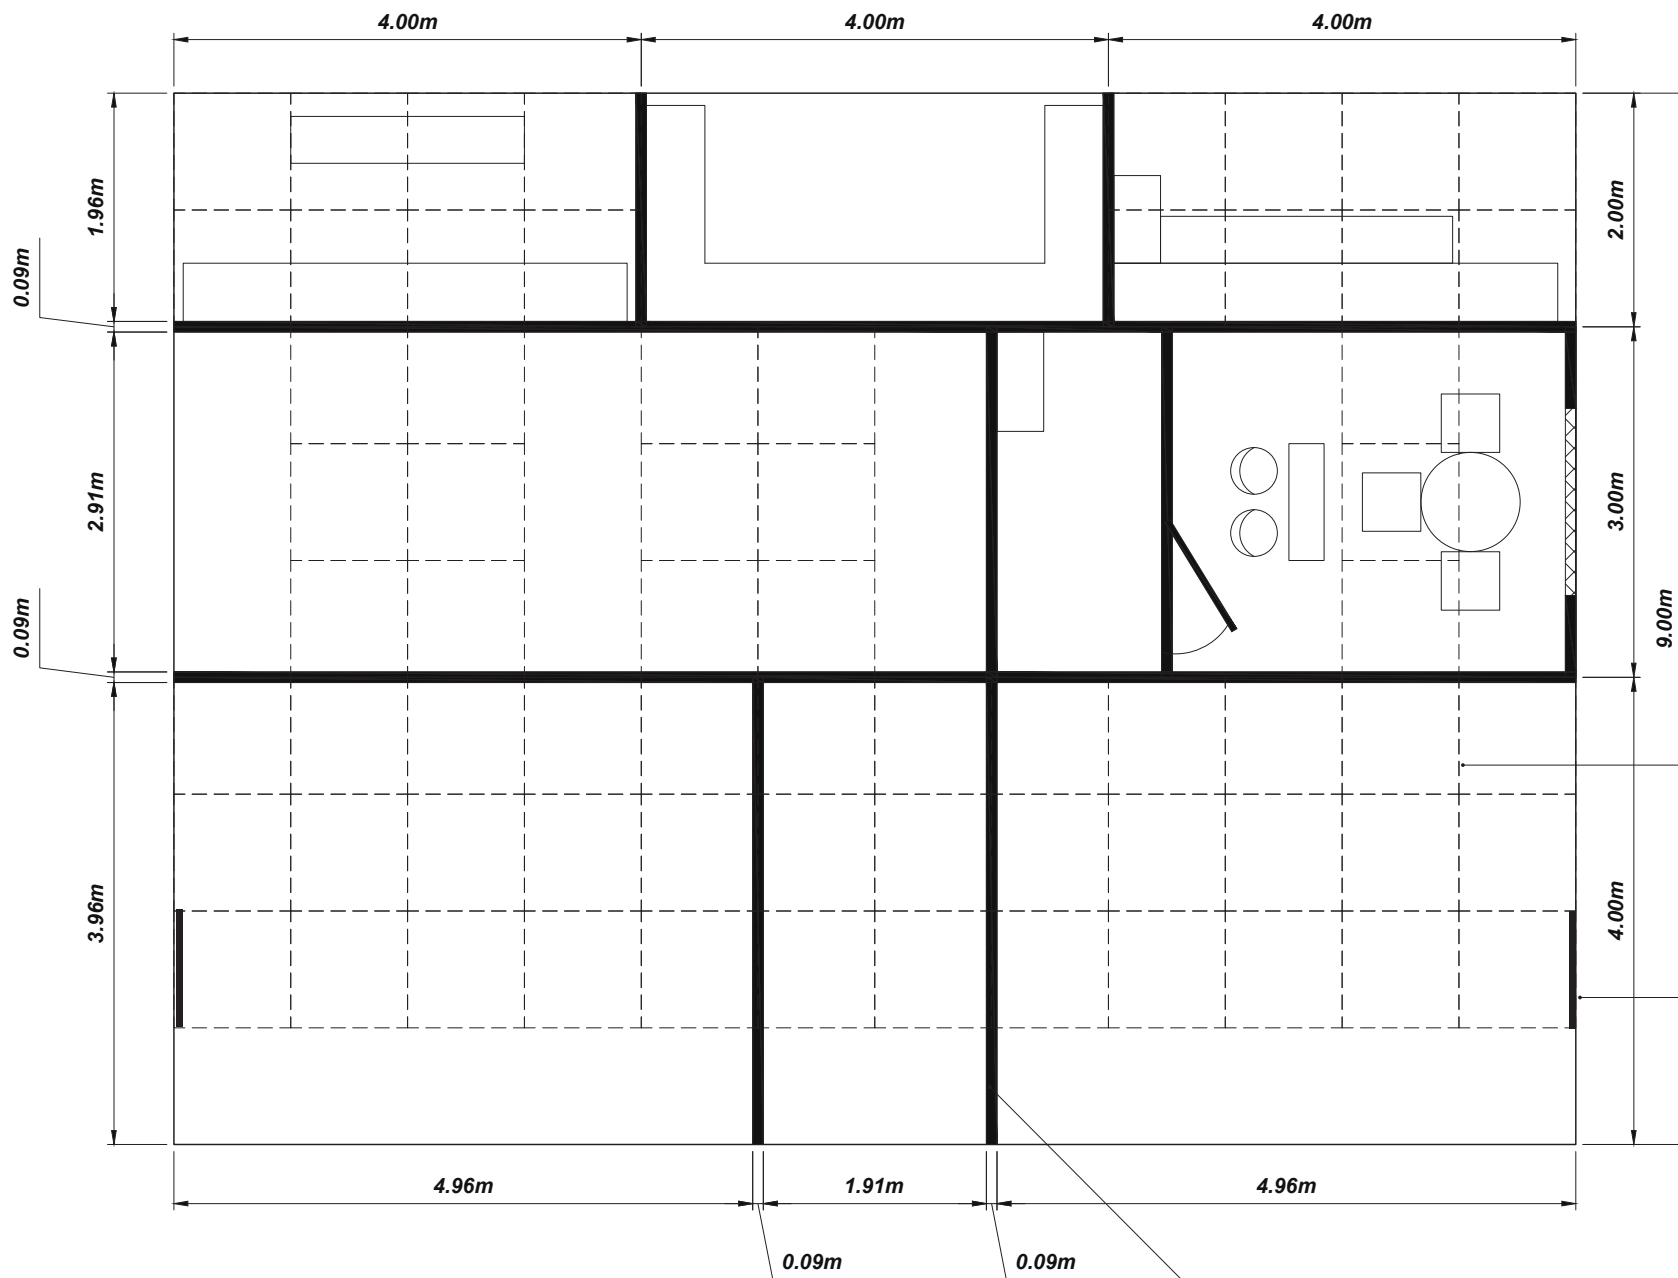

CEILING GRID

2" x 2"-3mm tubular steel
painted in flat white

CEILING GRID SUPPORT

2" x 2"-3mm tubular steel
Cladded in graphics

WOODEN WALL

3/4 THK Plywood with 2"x 2"
KD framing in approved paint finish

TITLE: PHILIPPINES PAVILION		
LOCATION: DWTC, UAE		
CONTENT:	DESIGNER:	
DETAILS	MIR	
DATE:	REVISION:	SHEET NO:
08/22/2019	01	5

FLOOR PLAN / PLOTTING

PHILIPPINES PAVILION

NOTE: CEILING GRID AND DISPLAY PROPS ARE NOT SHOWN FOR CLARITY




 EXHIBITION AND DESIGN DIVISION		
TITLE: PHILIPPINES PAVILION		
LOCATION: DWTC, UAE		
CONTENT: DETAILS	DESIGNER: MIR	
DATE: 08/22/2019	REVISION: 01	SHEET NO: 6

ELEVATION 1 A-1 & A2

PHILIPPINES PAVILION

NOTE: CEILING GRID AND DISPLAY PROPS ARE NOT SHOWN FOR CLARITY

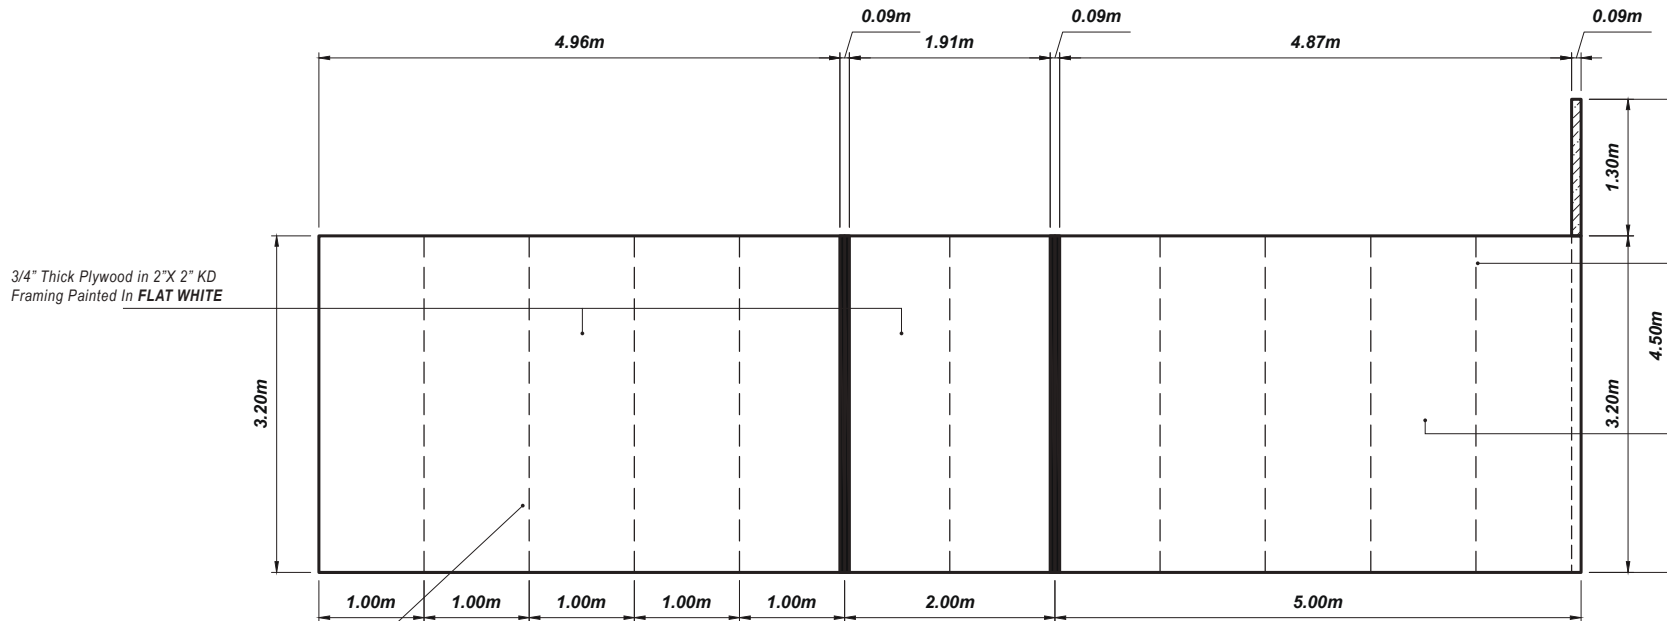

3/4" Thick Plywood in 2"X 2" KD Framing Painted In **FLAT WHITE**


VERTICAL WOODEN JOIST
2"x 2" KD Joist @ typical spacing of 1.00m

3/4" Thick Plywood in 2"X 2" KD Framing Painted In Pantone 427U
SOLID UNCOATED



VERTICAL WOODEN JOIST
2"x 2" KD Joist @ typical spacing of 1.00m

ELEVATION 1 A-1

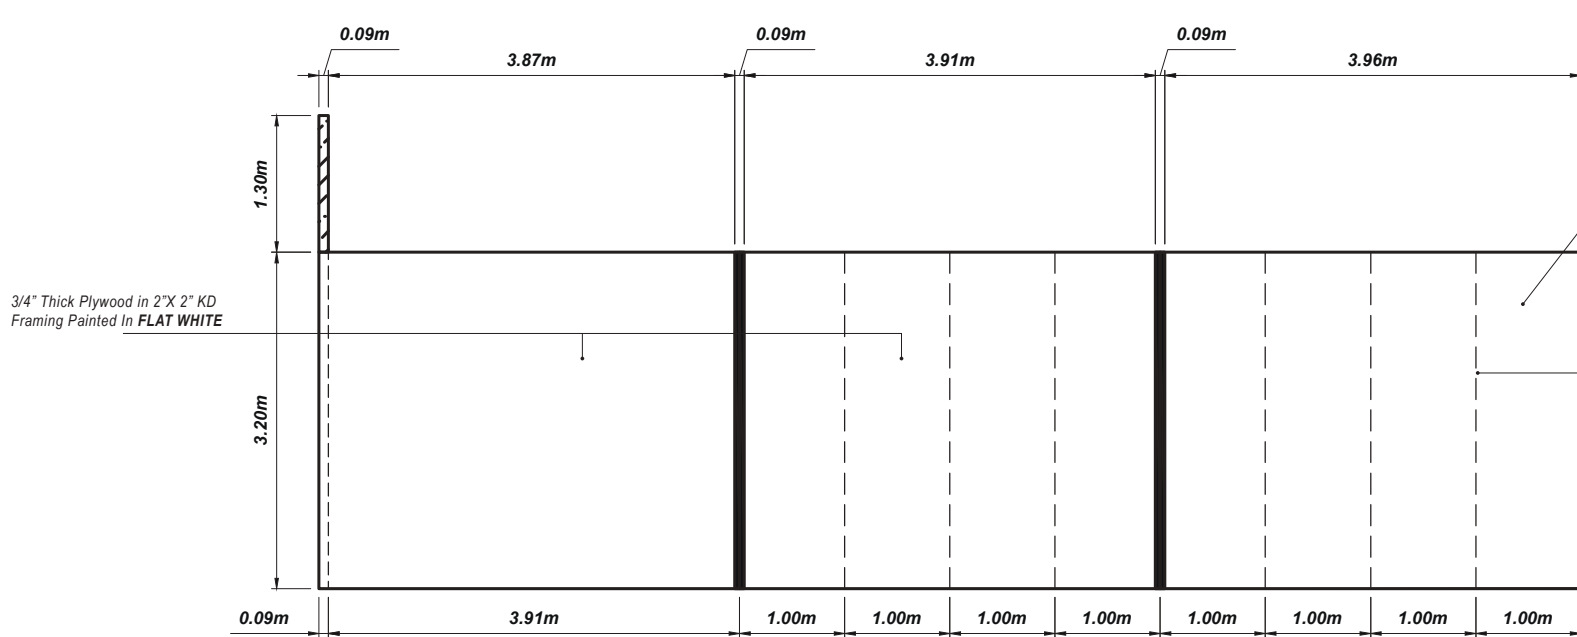

3/4" Thick Plywood in 2"X 2" KD Framing Painted In **FLAT WHITE**

3/4" Thick Plywood in 2"X 2" KD Framing Painted In Pantone 7538U
SOLID UNCOATED



VERTICAL WOODEN JOIST
2"x 2" KD Joist @ typical spacing of 1.00m

ELEVATION 1 A-2

CDEM EXHIBITION AND DESIGN DIVISION		
PROJECT: INDEX DUBAI 2019		
TITLE: PHILIPPINES PAVILION		
LOCATION: DWTC, UAE		
CONTENT: DETAILS	DESIGNER: MIR	
DATE: 08/22/2019	REVISION: 01	SHEET NO: 7

ELEVATION 1 A-3 & A4

PHILIPPINES PAVILION

NOTE: CEILING GRID AND DISPLAY PROPS ARE NOT SHOWN FOR CLARITY


VERTICAL WOODEN JOIST
2"x 2" KD Joist @ typical spacing of 1.00m

3/4" Thick Plywood in 2"X 2" KD
Framing Painted In Pantone 427U
SOLID UNCOATED



VERTICAL WOODEN JOIST
2"x 2" KD Joist @ typical spacing of 1.00m

3/4" Thick Plywood in 2"X 2" KD
Framing Painted In **FLAT WHITE**

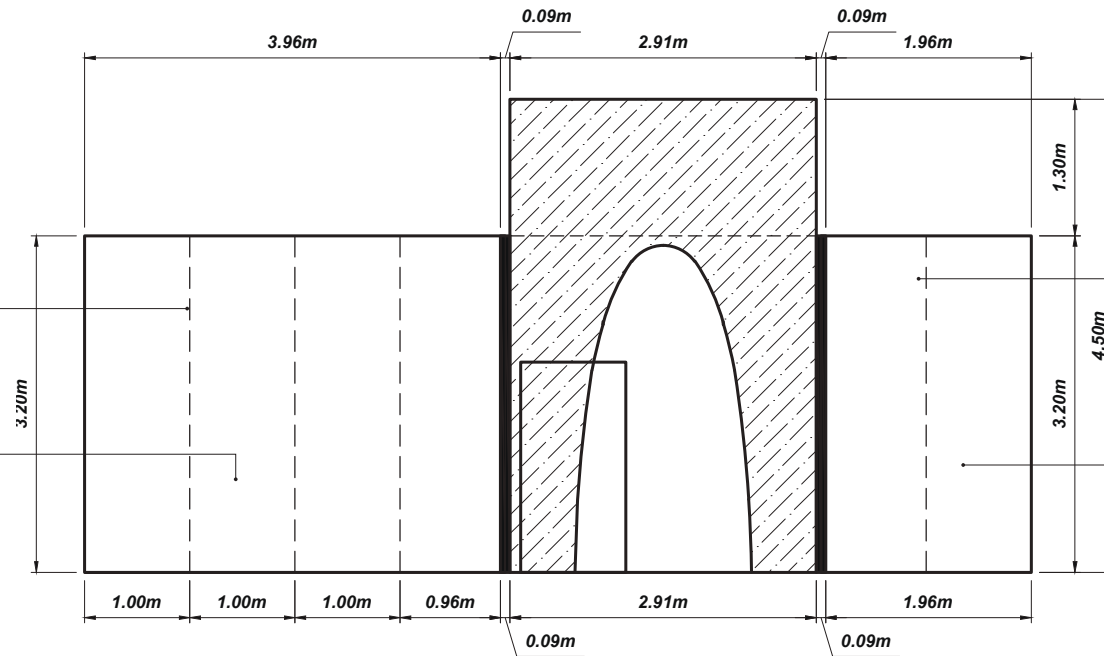


ELEVATION 1 A-3

VERTICAL WOODEN JOIST
2"x 2" KD Joist @ typical spacing of 1.00m



3/4" Thick Plywood in 2"X 2" KD
Framing Painted In **FLAT WHITE**

3/4" Thick Plywood in 2"X 2" KD
Framing Painted In **FLAT WHITE**

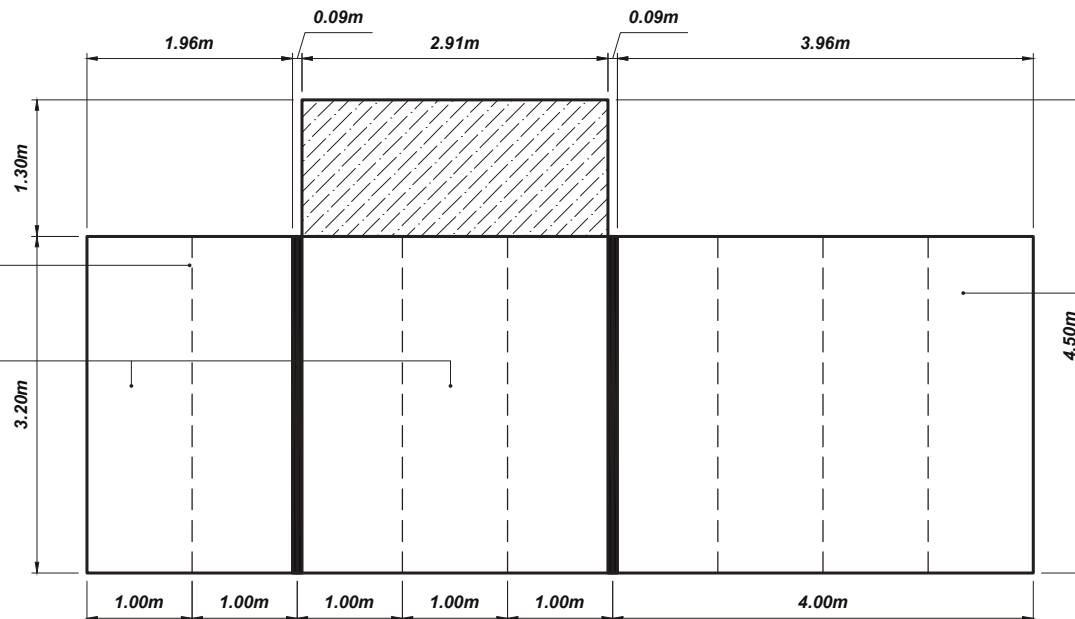

ELEVATION 1 A-4

PROJECT: INDEX DUBAI 2019		
TITLE: PHILIPPINES PAVILION		
LOCATION: DWTC, UAE		
CONTENT: DETAILS	DESIGNER: MIR	
DATE: 08/22/2019	REVISION: 01	SHEET NO: 8

 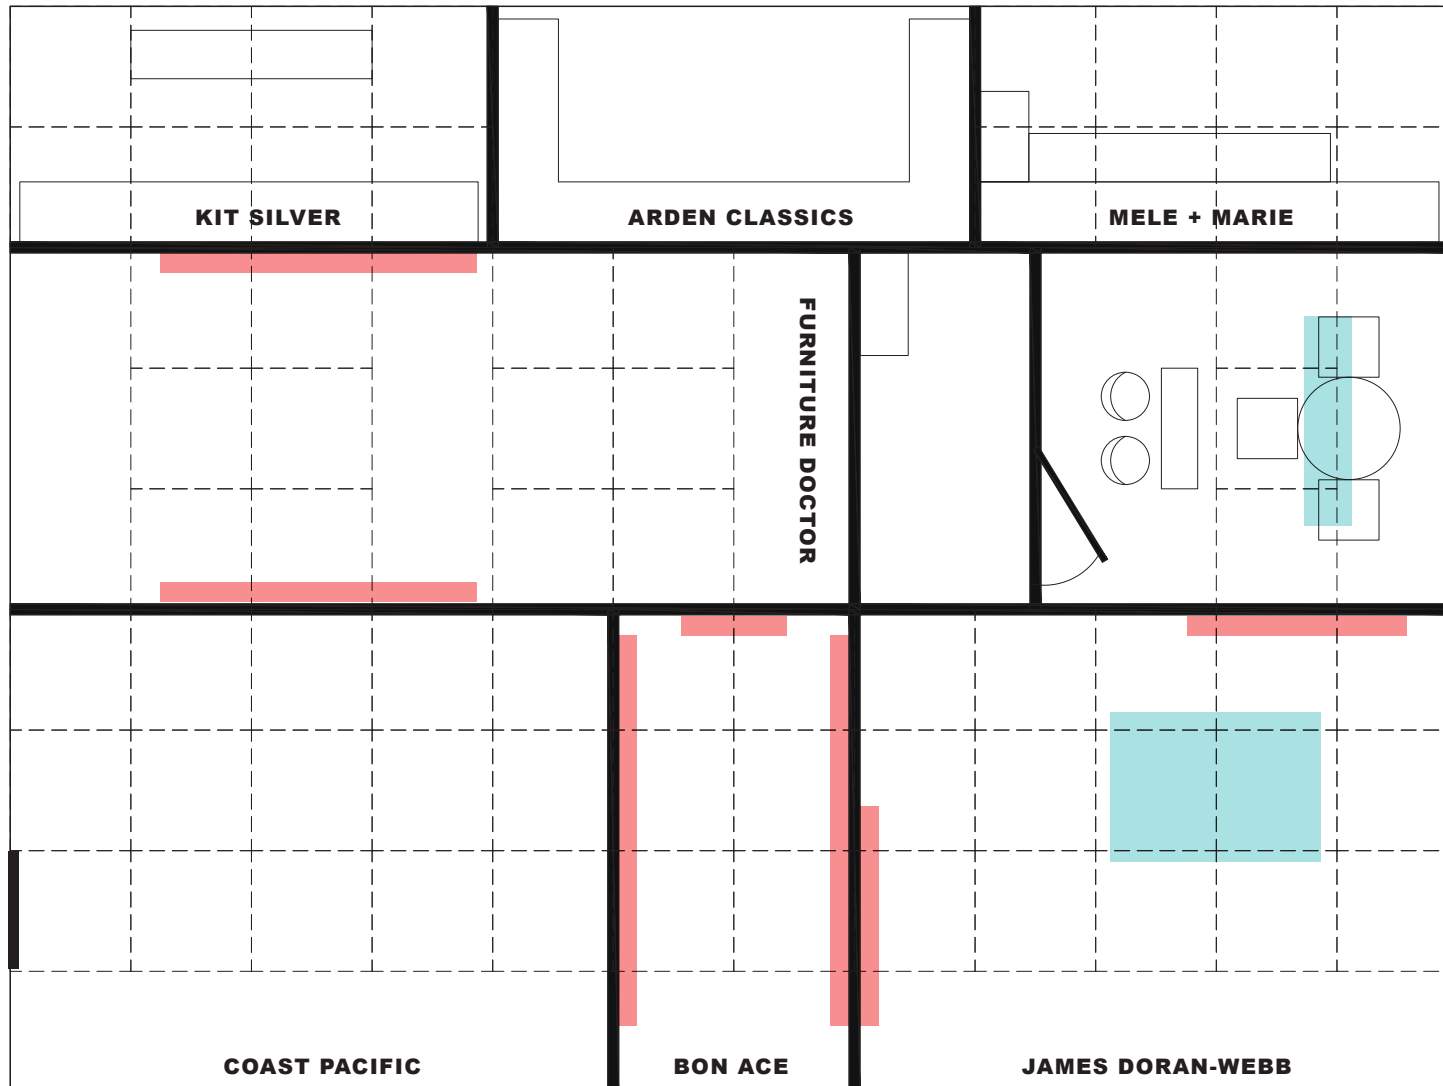


1. Hanging lamp in Cebu Homecrafts' (James Doran-Webb) area weighing 17 kgs.
2. Hanging lamp in the CITEM counter area weighing 17 kgs.
3. Pewter Mirror of Cebu Homecraft (James Doran- Webb) -- h 137 cm x w 92 cm x 9cm thk @ 20kg
4. 3d Mirror Cebu Homecraft (James Doran- Webb) -- h 160 cm x w 100 cm x 25 cm thk @ 30 kg
5. 2 Mirrors of Furniture Doctor weighing 17 kgs each.
6. Mirror of Bon – Ace @ 36 kgs
7. 2 walls of Bon -Ace (4 meters each) should be able to carry at least 12 kgs and 8 kgs of wall décor pieces.

 EXHIBITION AND DESIGN DIVISION		
PROJECT: INDEX DUBAI 2019		
TITLE: PHILIPPINES PAVILION		
LOCATION: DWTC, UAE		
CONTENT: DETAILS	DESIGNER: MIR	
DATE: 08/22/2019	REVISION: 01	SHEET NO: 9

CEILING GRID FLOOR PLAN

PHILIPPINES PAVILION

NOTE: DISPLAY PROPS ARE NOT SHOWN FOR CLARITY

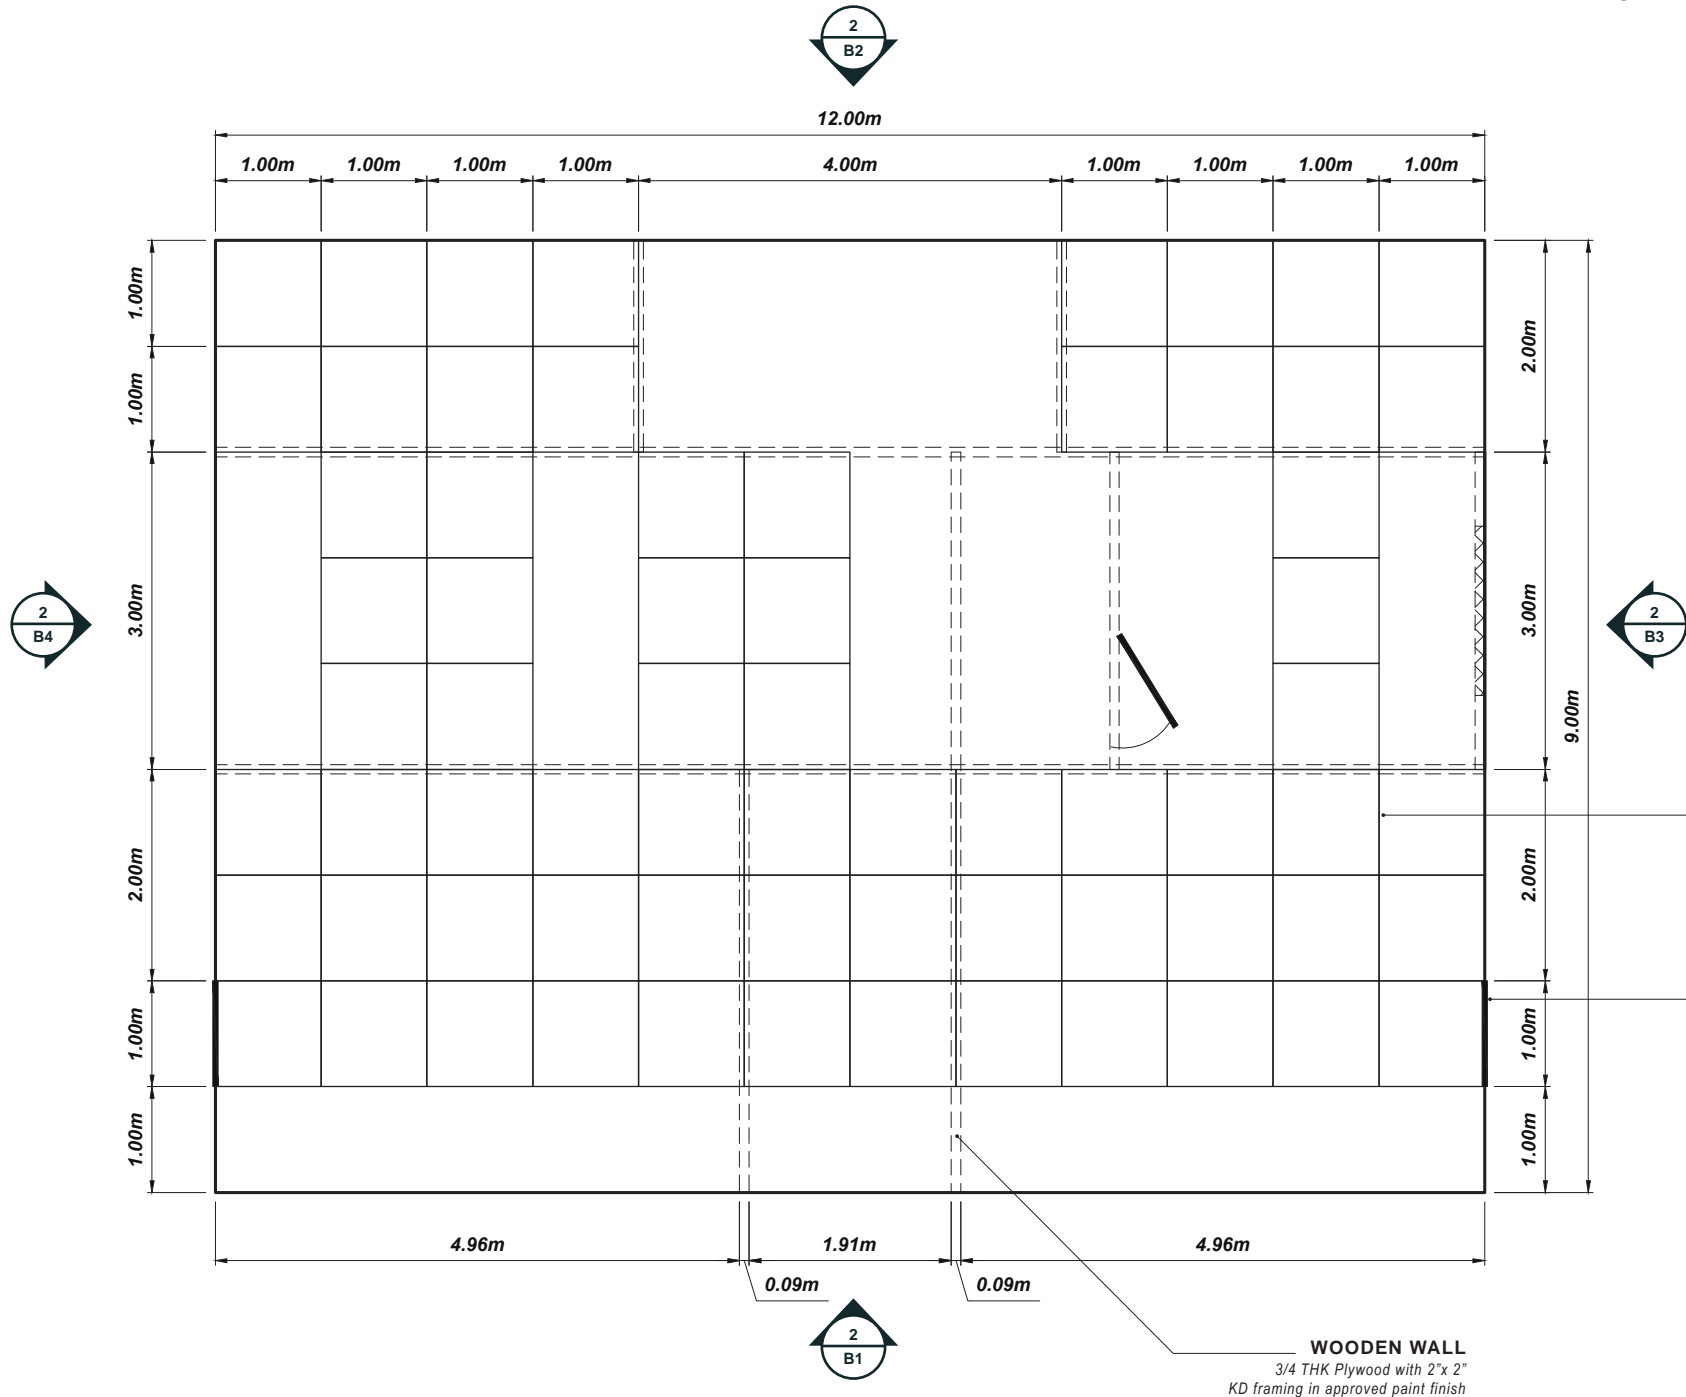

CEILING GRID
2" x 2"-3mm tubular steel
painted in flat white

CEILING GRID SUPPORT
2" x 2"-3mm tubular steel
Cladded in graphics


WOODEN WALL
3/4 THK Plywood with 2"x 2"
KD framing in approved paint finish

 EXHIBITION AND DESIGN DIVISION		
PROJECT: INDEX DUBAI 2019		
TITLE: PHILIPPINES PAVILION		
LOCATION: DWTC, UAE		
CONTENT: DETAILS	DESIGNER: MIR	
DATE: 08/22/2019	REVISION: 01	SHEET NO: 10


ELEVATION 2 B1 & B2

PHILIPPINES PAVILION

NOTE: DISPLAY PROPS ARE NOT SHOWN FOR CLARITY

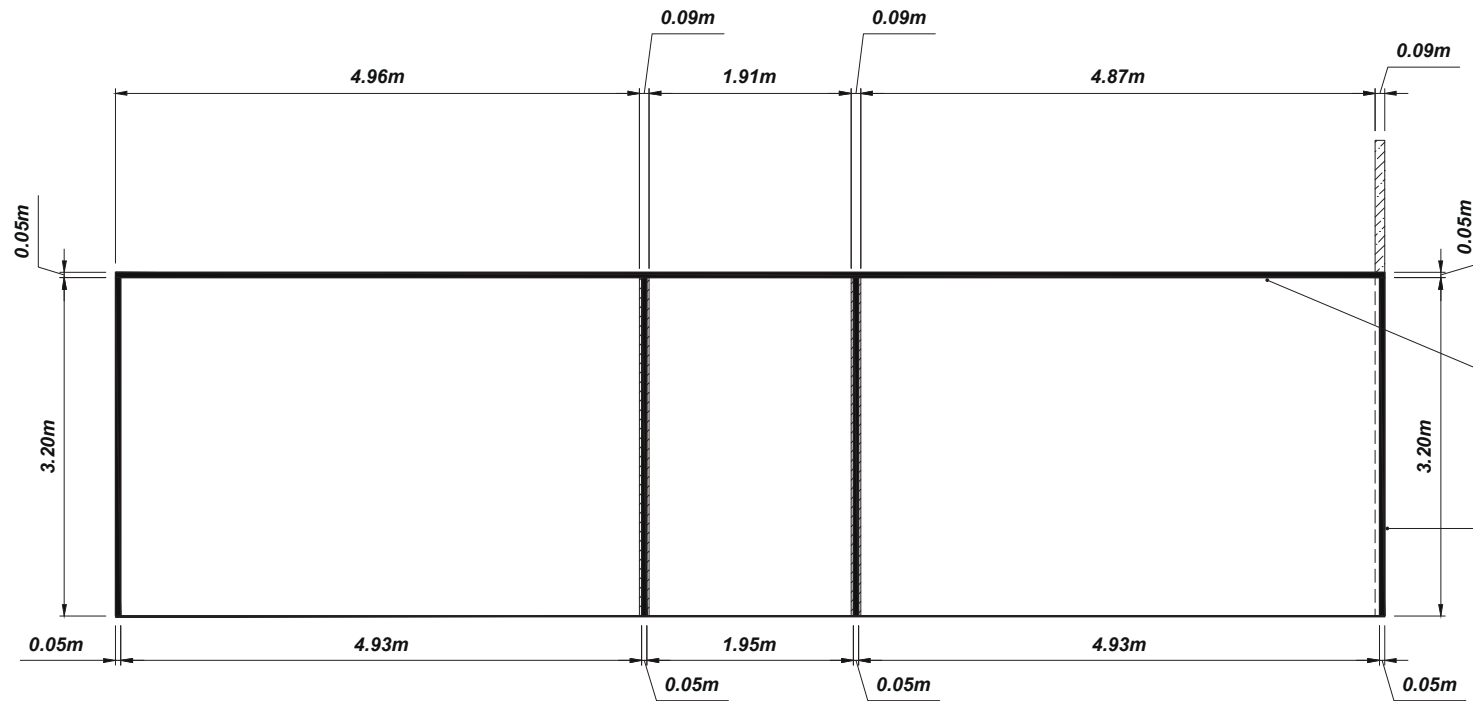

ELEVATION 2 B-1

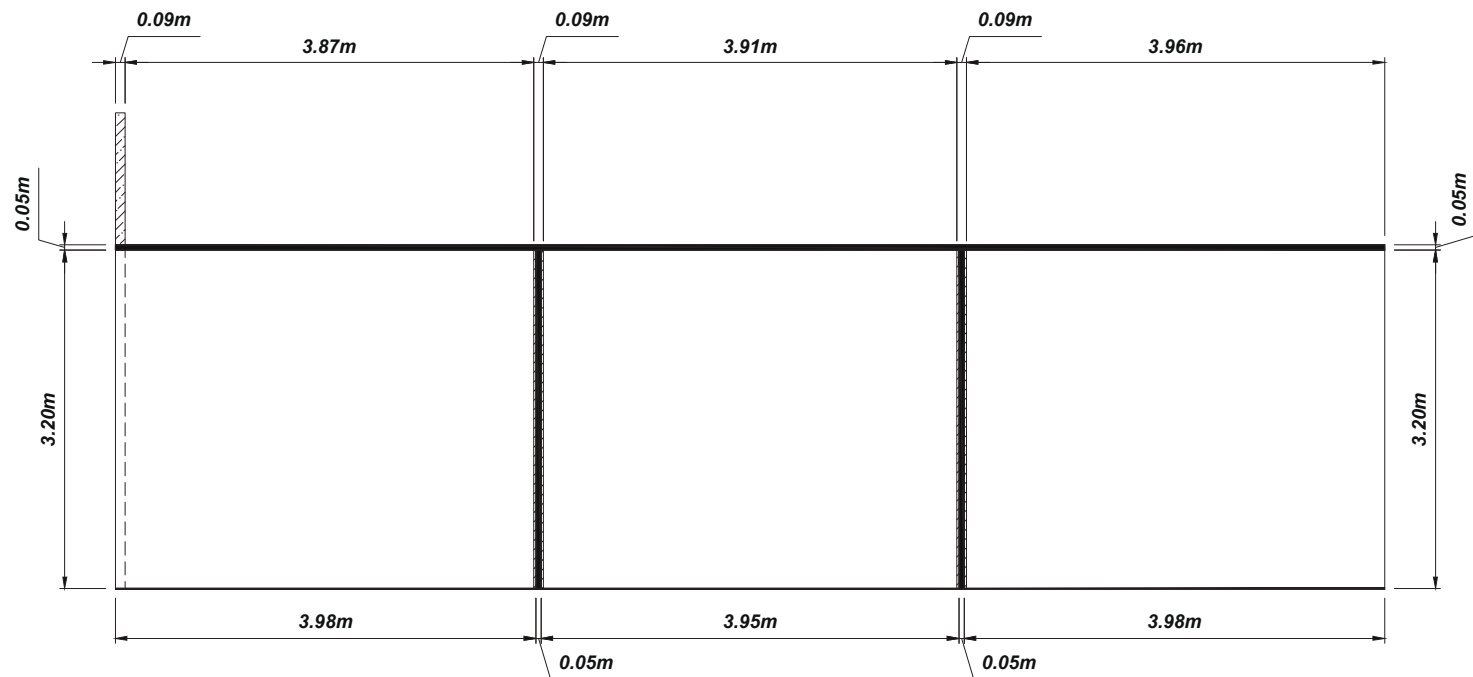

ELEVATION 2 B-2


PROJECT: INDEX DUBAI 2019		
TITLE: PHILIPPINES PAVILION		
LOCATION: DWTC, UAE		
CONTENT: DETAILS	DESIGNER: MIR	
DATE: 08/22/2019	REVISION: 01	SHEET NO: 11

ELEVATION 2 B3 & B4

PHILIPPINES PAVILION

NOTE: DISPLAY PROPS ARE NOT SHOWN FOR CLARITY


CEILING GRID SUPPORT
2" x 2"-3mm tubular steel
Cladded in graphics

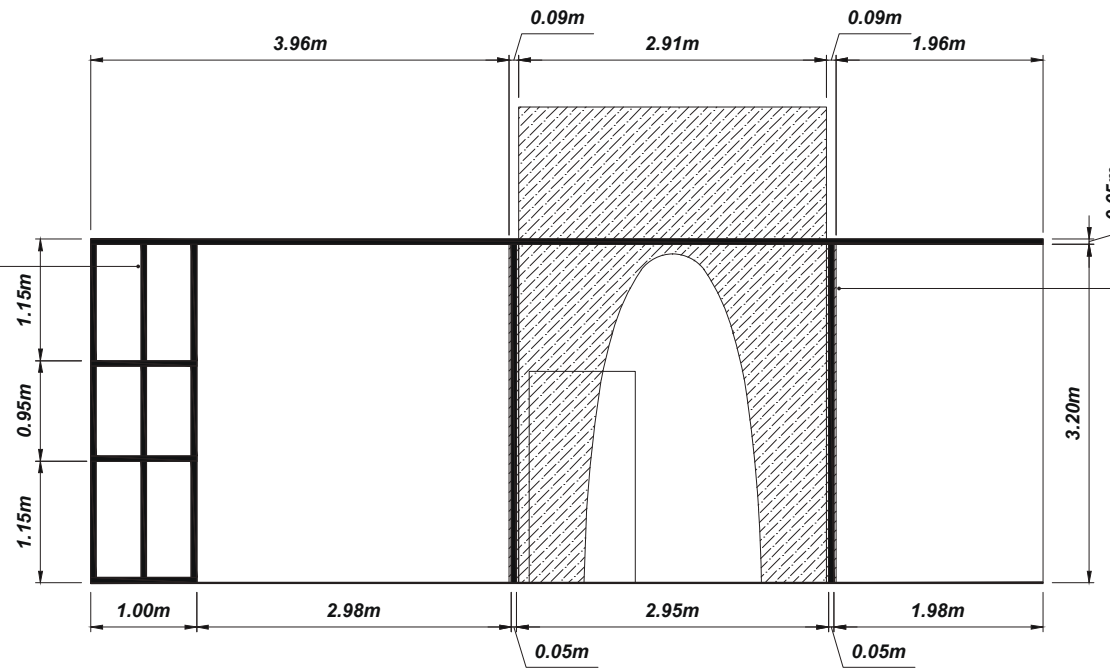

CEILING GRID POST
2" x 2"-3mm tubular steel
painted in flat white

ELEVATION 2 B-3

CEILING GRID POST
2" x 2"-3mm tubular steel
painted in flat white

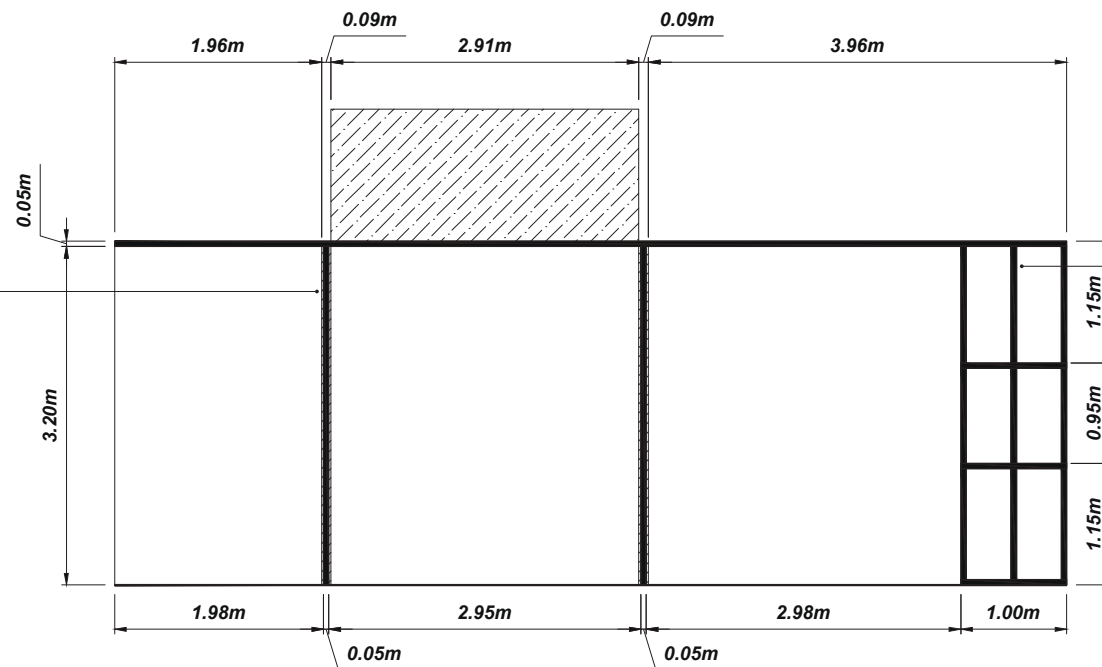


CEILING GRID SUPPORT
2" x 2"-3mm tubular steel
Cladded in graphics

ELEVATION 2 B-4

PROJECT: INDEX DUBAI 2019		
TITLE: PHILIPPINES PAVILION		
LOCATION: DWTC, UAE		
CONTENT: DETAILS	DESIGNER: MIR	
DATE: 08/22/2019	REVISION: 01	SHEET NO: 12

S01 - CITEM AREA DETAIL
PHILIPPINES PAVILION

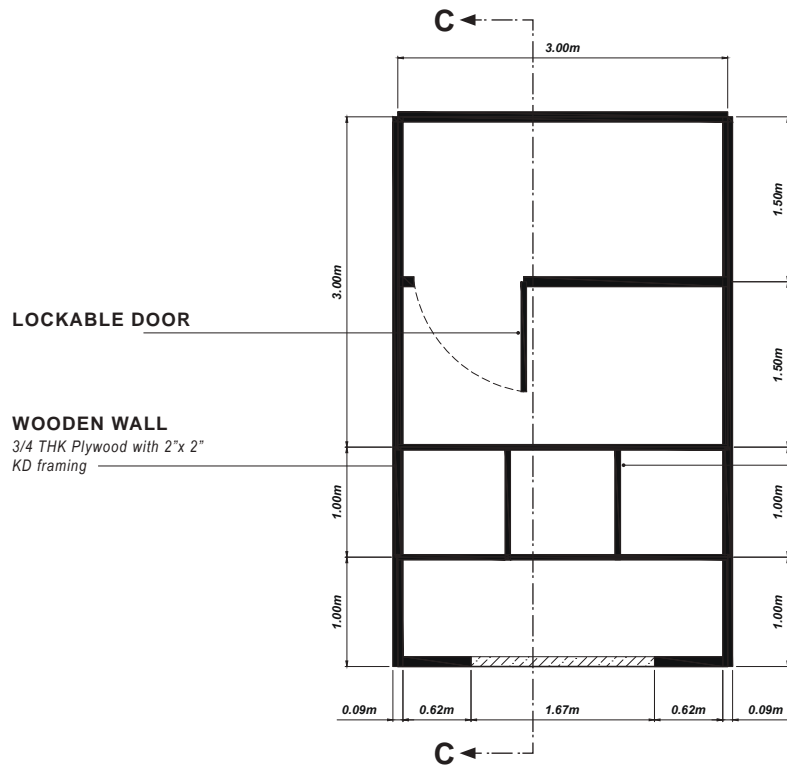

LOCKABLE DOOR

WOODEN WALL
3/4 THK Plywood with 2" x 2" KD framing


CEILING GRID
2" x 2"-3mm tubular steel painted in flat white

S02 DETAILS ON PAGE 13


WOODEN ARCH
3/4 THK Plywood with 2" x 2" KD framing clad in graphics

WOODEN WALL
3/4 THK Plywood with 2" x 2" KD framing

LOCKABLE DOOR

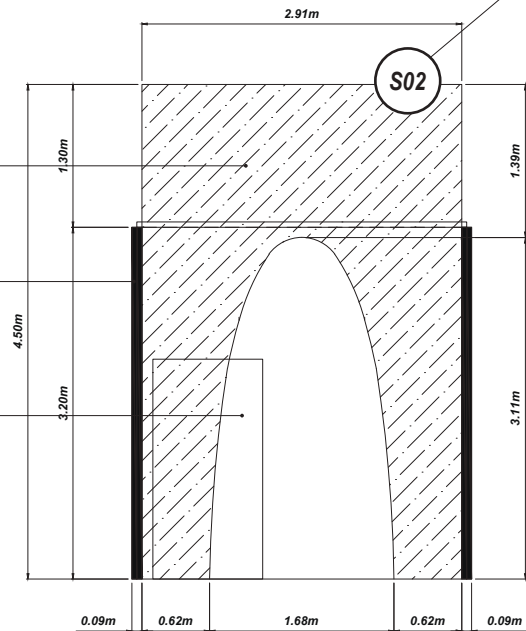

S02

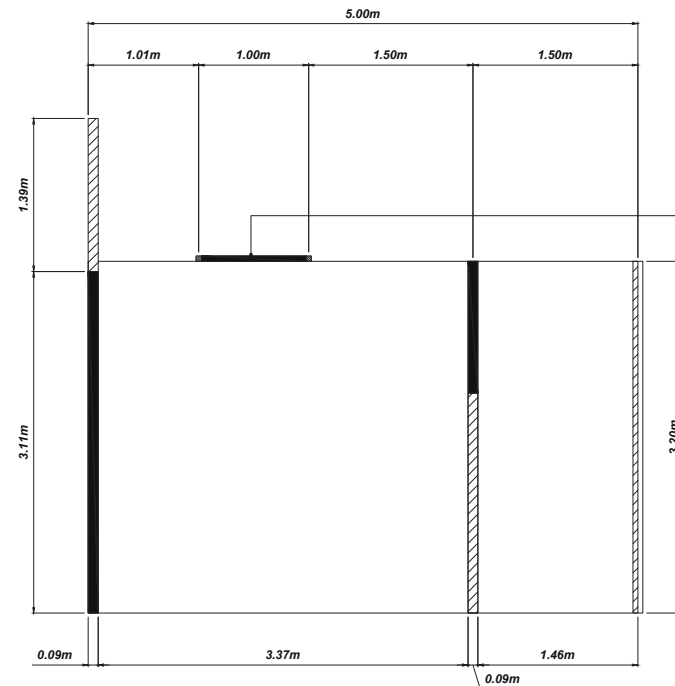


CEILING GRID
2" x 2"-3mm tubular steel painted in flat white


SECTION C-C

Citem EXHIBITION AND DESIGN DIVISION		
PROJECT: INDEX DUBAI 2019		
TITLE: PHILIPPINES PAVILION		
LOCATION: DWTC, UAE		
CONTENT: DETAILS	DESIGNER: MIR	
DATE: 08/22/2019	REVISION: 01	SHEET NO: 13

LETTER CUT-OUT
Backlighted wooden / PVC cut-out
0.33m x 2.31m x 4" THK

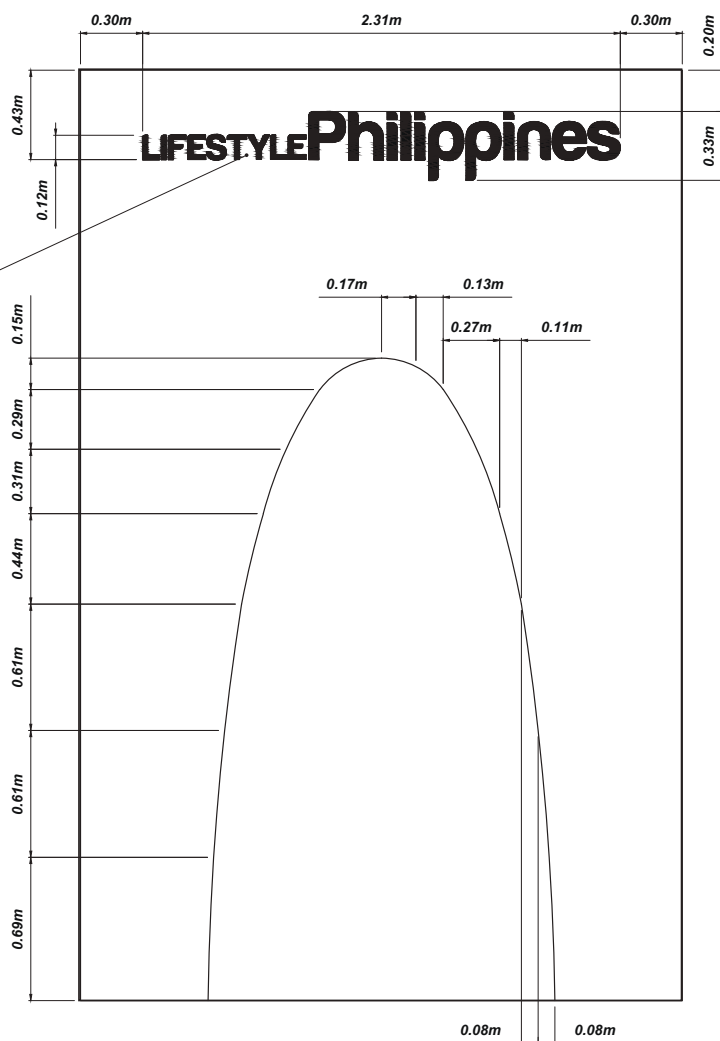


WOODEN ARCH
3/4 THK Plywood with 2"x 2"
KD framing clad in graphics

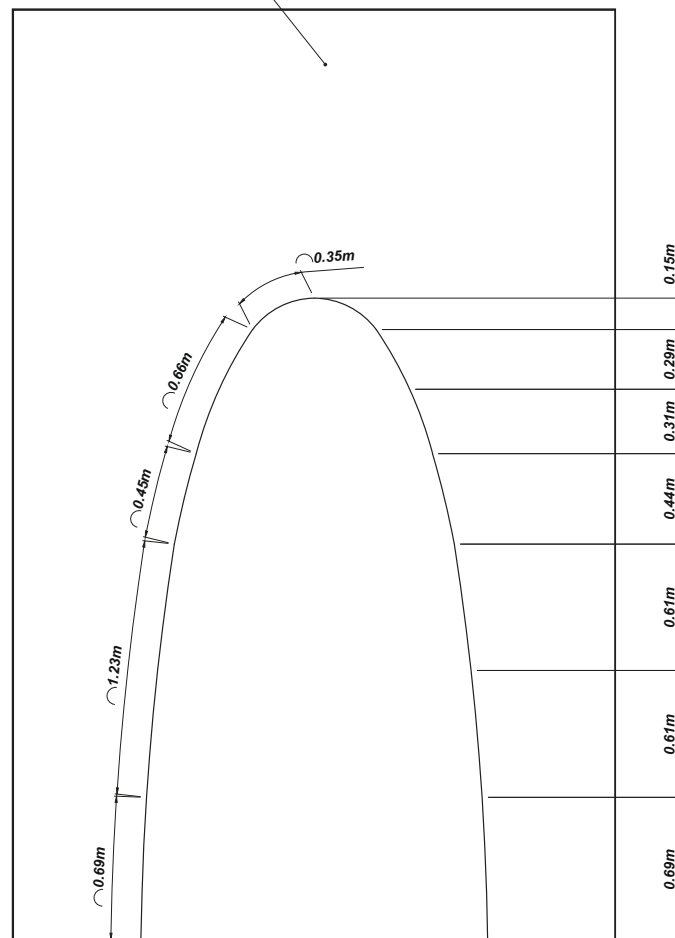


 EXHIBITION AND DESIGN DIVISION		
PROJECT: INDEX DUBAI 2019		
TITLE: PHILIPPINES PAVILION		
LOCATION: DWTC, UAE		
CONTENT: DETAILS	DESIGNER: MIR	
DATE: 08/22/2019	REVISION: 01	SHEET NO: 14


DISPLAY TABLE-01
1 UNIT

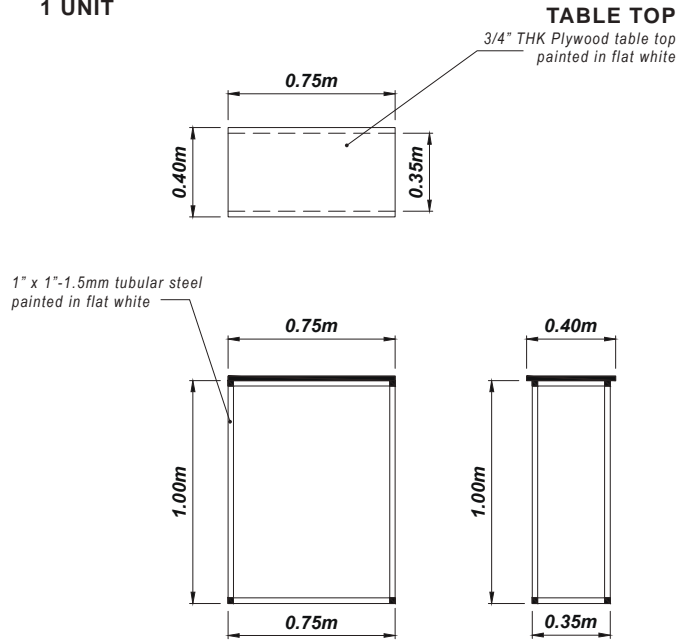

DISPLAY TABLE-02
1 UNIT


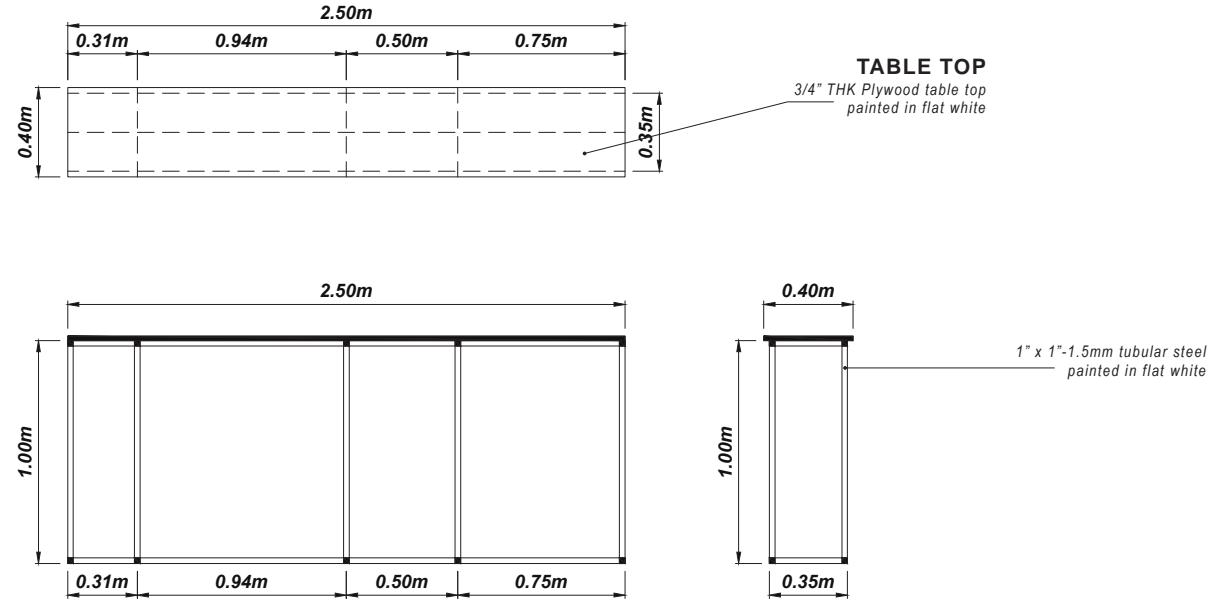


DISPLAY TABLE-03
1 UNIT


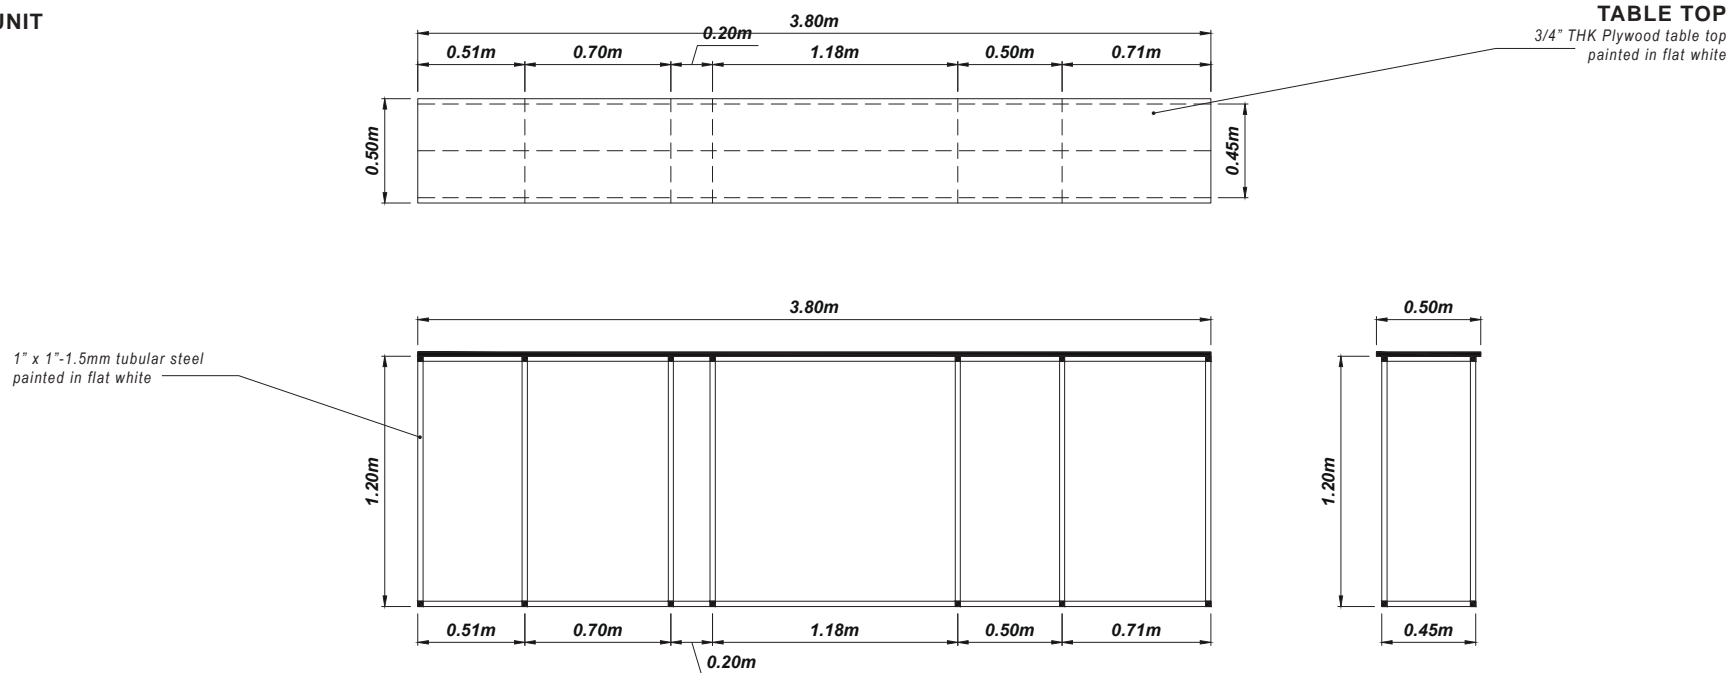


Citem EXHIBITION AND DESIGN DIVISION		
PROJECT: INDEX DUBAI 2019		
TITLE: PHILIPPINES PAVILION		
LOCATION: DWTC, UAE		
CONTENT: DETAILS	DESIGNER: MIR	
DATE: 08/22/2019	REVISION: 01	SHEET NO: 15

DISPLAY TABLE-04
1 UNIT




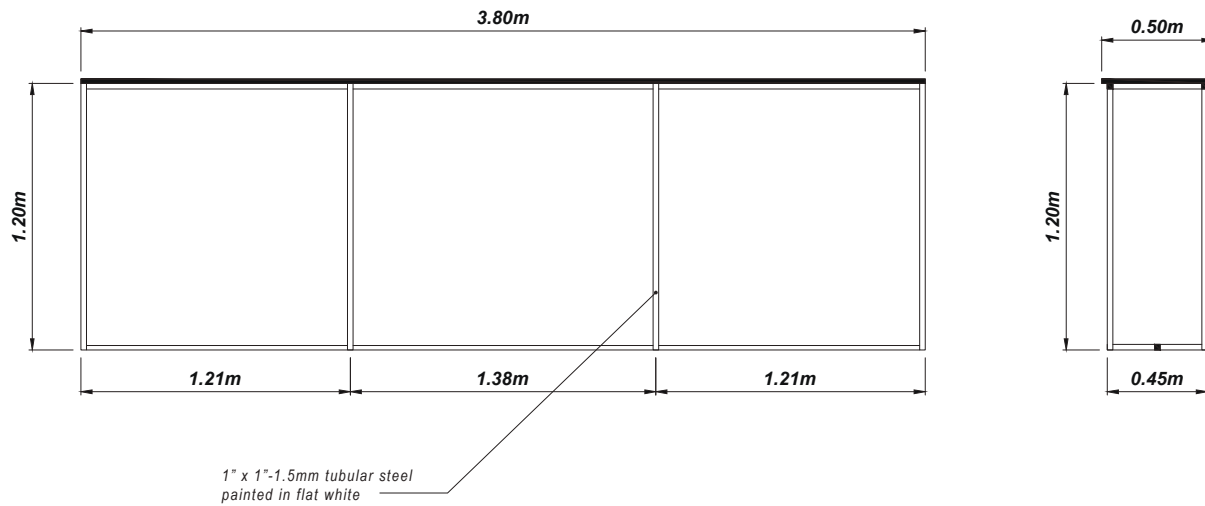
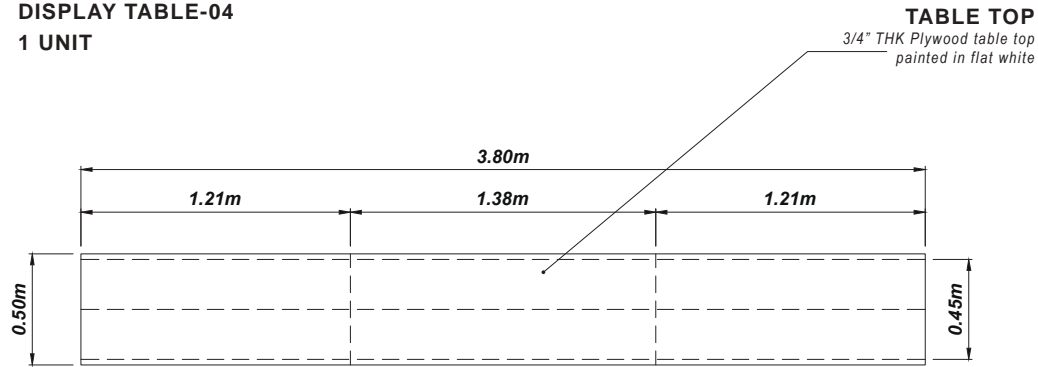


DISPLAY TABLE-05
1 UNIT

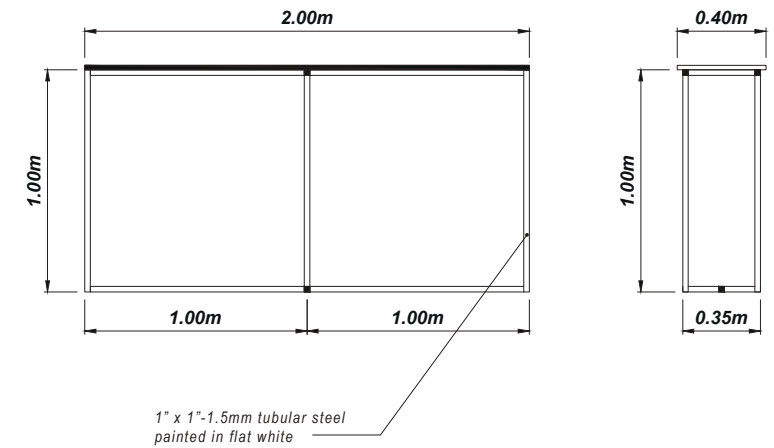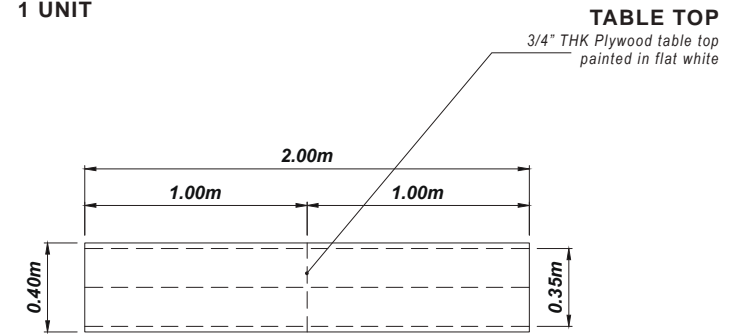


 EXHIBITION AND DESIGN DIVISION		
PROJECT: INDEX DUBAI 2019		
TITLE: PHILIPPINES PAVILION		
LOCATION: DWTC, UAE		
CONTENT: DETAILS	DESIGNER: MIR	
DATE: 08/22/2019	REVISION: 01	SHEET NO: 16

WOODEN LIGHT BOX
1 UNIT

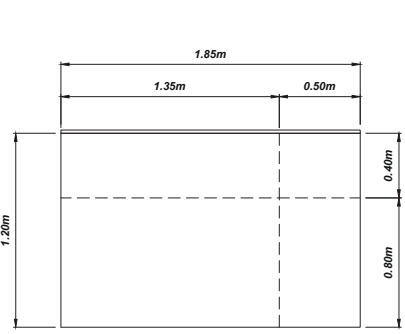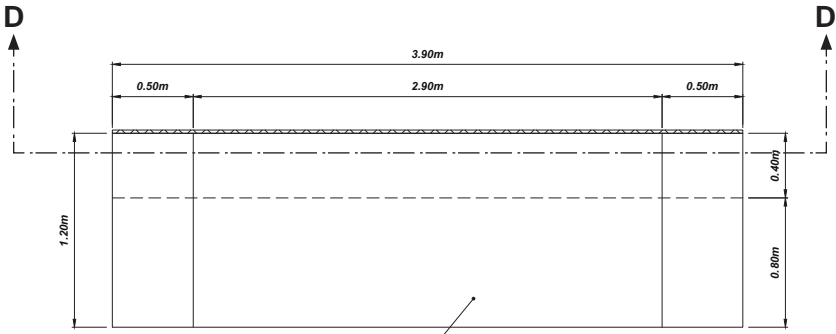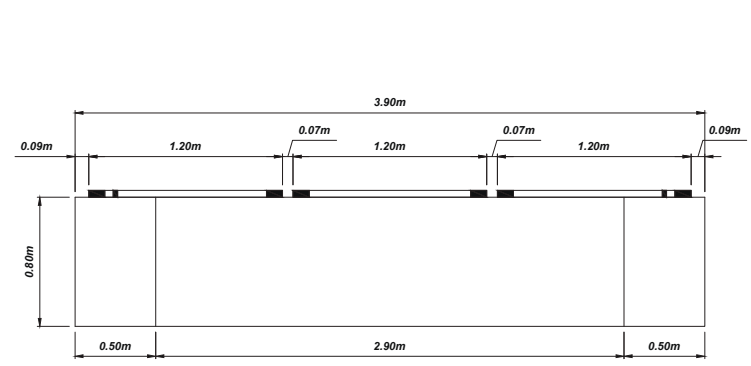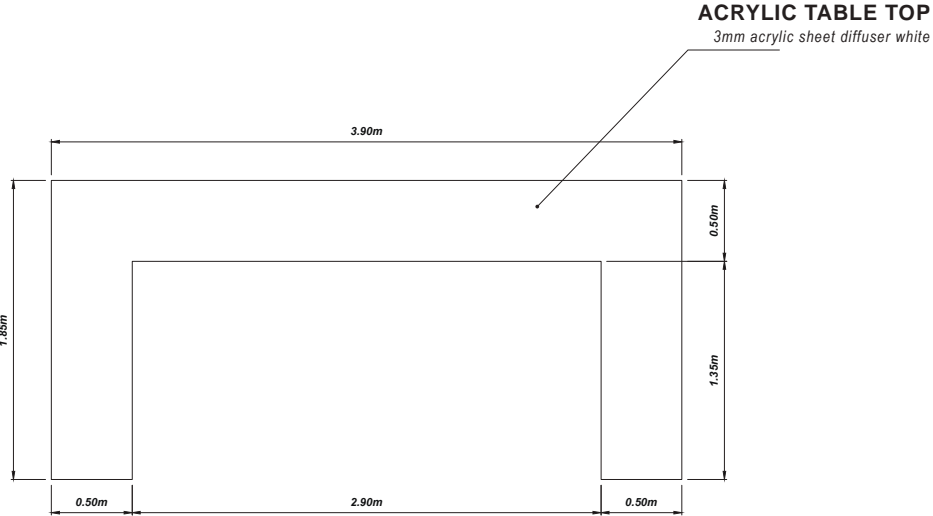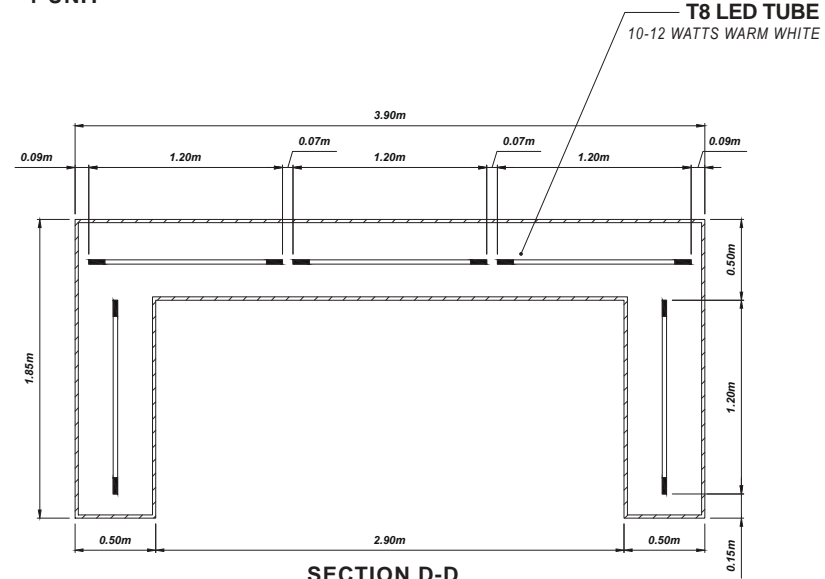

EXHIBITION AND DESIGN DIVISION		
PROJECT: INDEX DUBAI 2019		
TITLE: PHILIPPINES PAVILION		
LOCATION: DWTC, UAE		
CONTENT: DETAILS	DESIGNER: MIR	
DATE: 08/22/2019	REVISION: 01	SHEET NO: 17

***RECEPTION COUNTER**
1 UNIT

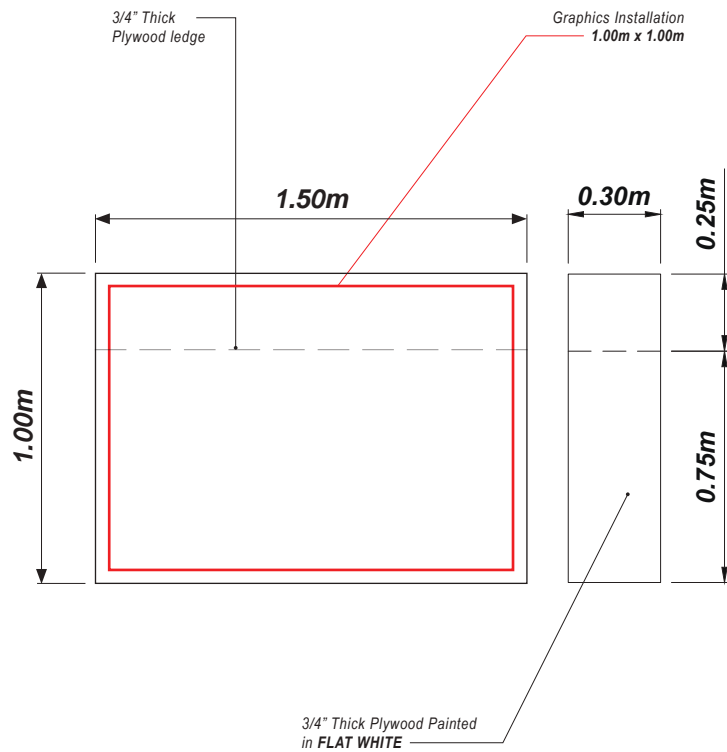

1 UNIT - IKEA BROR

<https://www.ikea.com/ae/en/p/bror-shelving-unit-black-s49282994/>



BROR

Shelving unit, black, 85x40x190 cm

Dhs 575

Price incl. VAT

This storage system is our interpretation of heavy metal – sturdy, durable and flexible. Also easy to assemble, complete as needed and is robust enough to withstand moisture, dirt and heavy loads. [Read More](#)

→ Quantity

– 1 +


Add to shopping bag





Add to wish list

Not quite perfect? Design your own!
 Use our planning tool to create your own customised combination.
[Open planner](#)

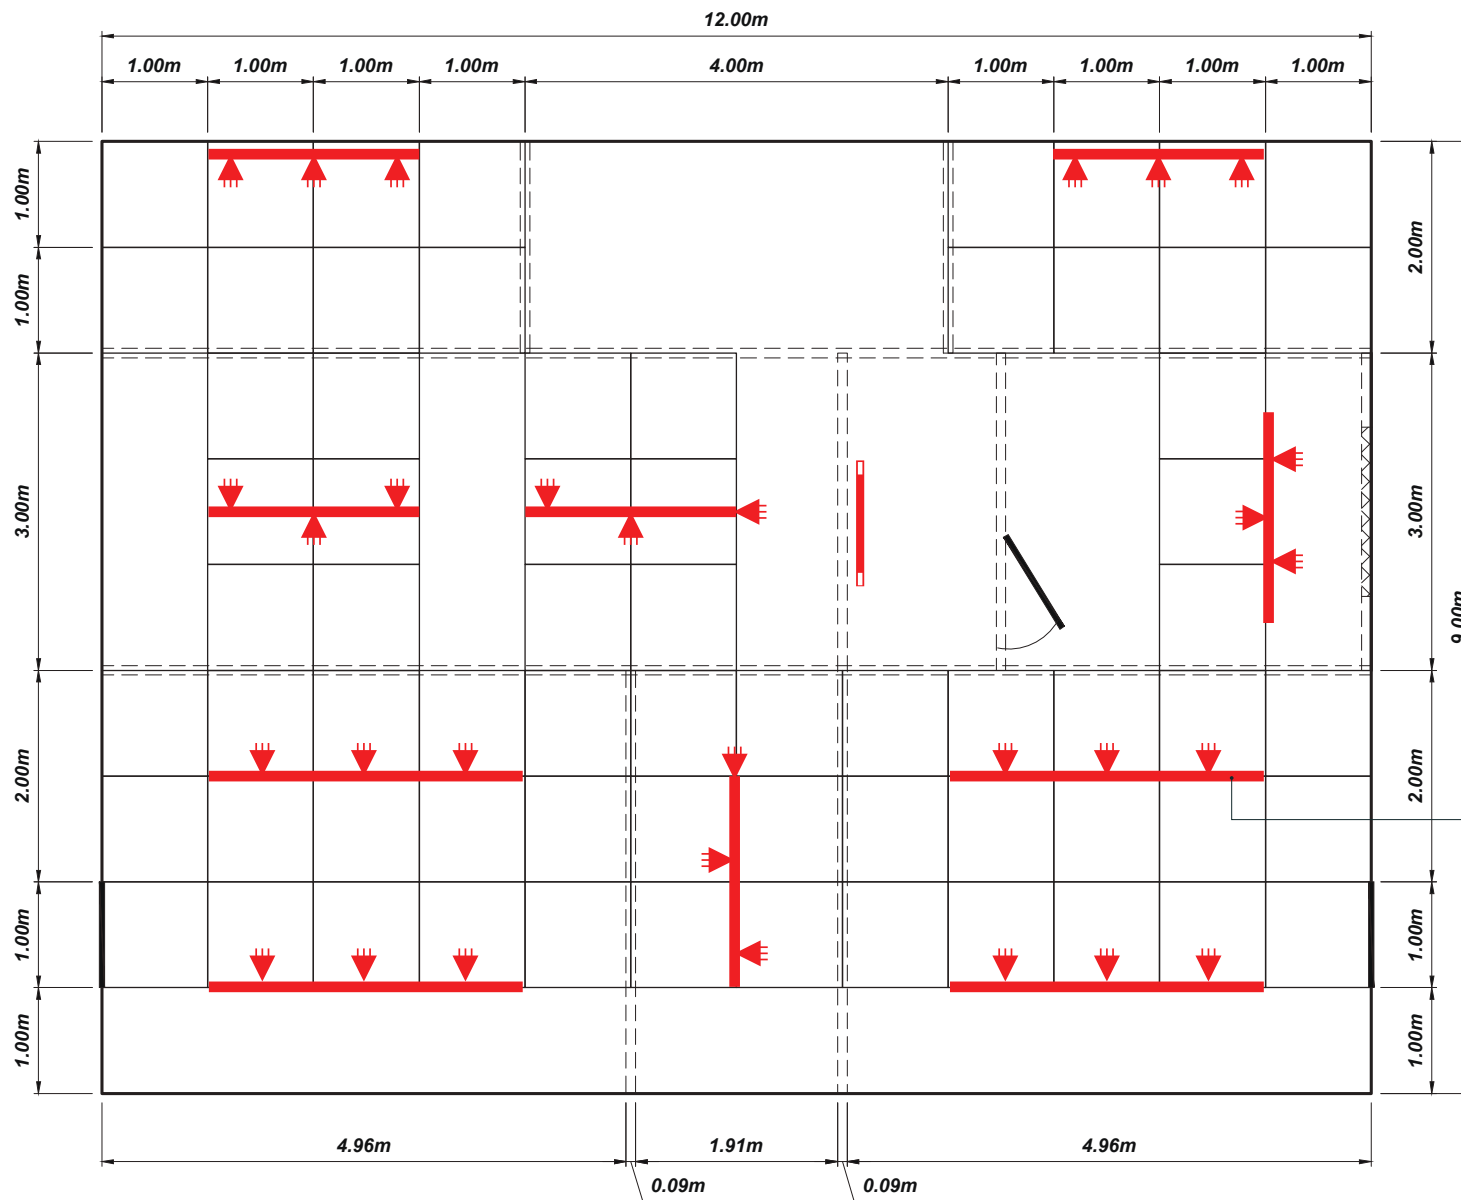EXHIBITION AND DESIGN DIVISION		
PROJECT: INDEX DUBAI 2019		
TITLE: PHILIPPINES PAVILION		
LOCATION: DWTC, UAE		
CONTENT: DETAILS	DESIGNER: MIR	
DATE: 08/22/2019	REVISION: 01	SHEET NO: 18

LIGHTING PLAN
PHILIPPINES PAVILION




- 30 units**  20watts warm white Tracklight(white casing)
- 6 units**  2.00m White Trackbar
- 4 units**  3.00m White Trackbar
- 1 unit**  10-12watts T8 LED tube


TRACK LIGHTING
Typical Elevation Level @ 3.25mH

 EXHIBITION AND DESIGN DIVISION		
PROJECT: INDEX DUBAI 2019		
TITLE: PHILIPPINES PAVILION		
LOCATION: DWTC, UAE		
CONTENT: DETAILS	DESIGNER: MIR	
DATE: 08/22/2019	REVISION: 01	SHEET NO: 19

ELECTRICAL PLAN
PHILIPPINES PAVILION

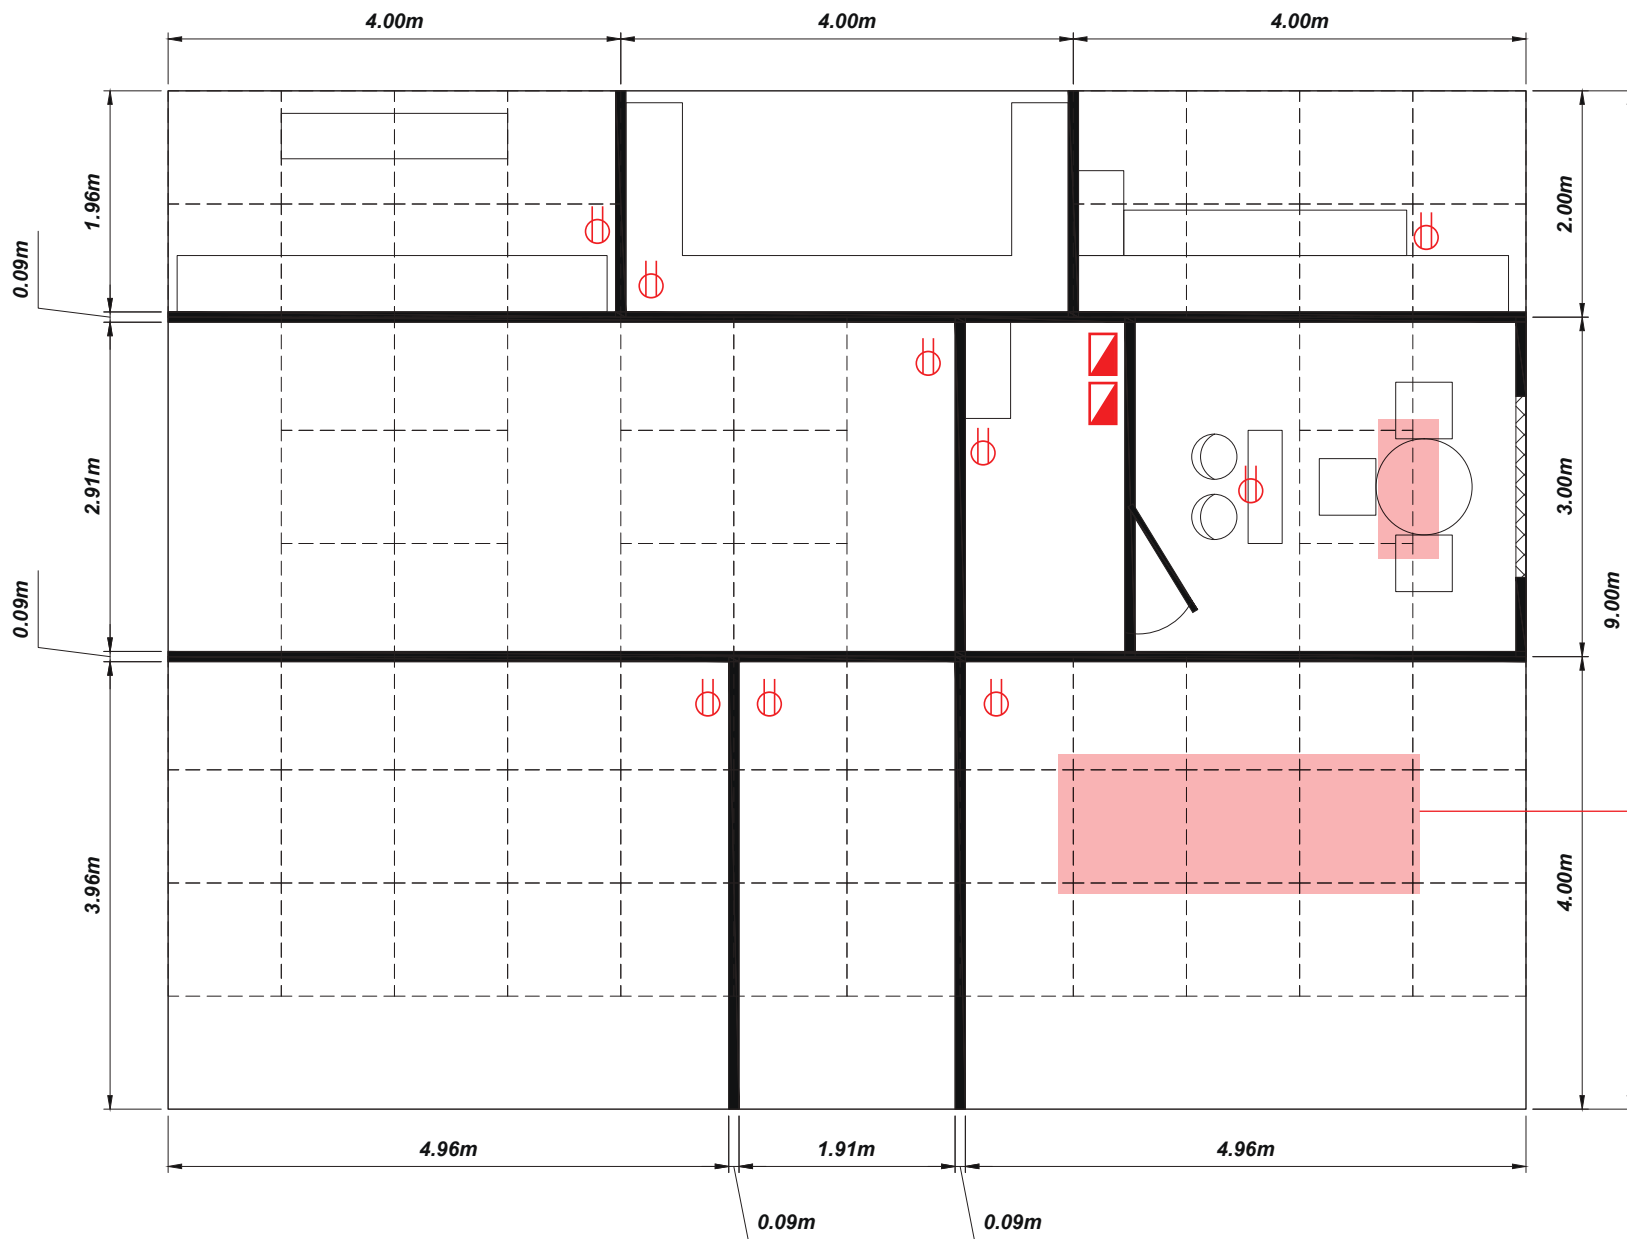

 9 units
2 Gang Convenience outlet

 2 units
Circuit Breaker

****NOTE: HIGHLIGHTED AREA
PROVISION FOR ELECTRICAL
OF HANGING ITEMS**

 EXHIBITION AND DESIGN DIVISION		
PROJECT: INDEX DUBAI 2019		
TITLE: PHILIPPINES PAVILION		
LOCATION: DWTC, UAE		
CONTENT: DETAILS	DESIGNER: MIR	
DATE: 08/22/2019	REVISION: 01	SHEET NO: 20

1 UNIT - IKEA GAMLARED

<https://www.ikea.com/ae/en/p/gamlared-table-light-antique-stain-black-stained-30371240/>



GAMLARED

Table, light antique stain, black stained, 85 cm

Dhs 295

Price incl. VAT

A round table is a social table and this one invites to relaxed conversation. The warm wood and soft, rounded edges create a cosy and relaxed atmosphere. Easy to place anywhere in the home. [Read More](#)



Quantity

- 1 +

Add to shopping bag

Add to wish list

***4 UNITS - IKEA SVENBERTIL**

<https://www.ikea.com/ae/en/p/svenbertil-chair-black-bronze-black-s99197696/>



SVENBERTIL

Chair, black, Bronze/black

Dhs 155

Price incl. VAT

(Jul 4, 2019 - Aug 3, 2019 or while supplies last)

~~Dhs 175~~

Price incl. VAT

Choose your favourite underframe and seat shell, or create a playful mix around the table. Up to 30 different chair combinations are possible! You sit comfortably thanks to the scooped seat and back. [Read More](#)



Quantity

- 1 +

Add to shopping bag

Add to wish list

EXHIBITION AND DESIGN DIVISION		
PROJECT: INDEX DUBAI 2019		
TITLE: PHILIPPINES PAVILION		
LOCATION: DWTC, UAE		
CONTENT: DETAILS	DESIGNER: MIR	
DATE: 08/22/2019	REVISION: 01	SHEET NO: 21

I. MAIN CONSTRUCTION / FABRICATION / INSTALLATION / DISMANTLING		TOTAL QTY.
I.A) PAVILION CARPET (COLOR VARIES PER EXHIBITOR)	SEE DETAILS	108 SQ.M.
I.B) PAVILION STRUCTURE / WALLS (3/4" THK Plywood with 2" x 2" KD framing in approved paint finish)	SEE DETAILS	1 LOT
I.C) PAVILION CEILING GRID (2" x 2" tubular steel in flat white finish)	SEE DETAILS	1 LOT
I.D) RECEPTION COUNTER (0.30m x 1.50m x 1.00mH)	SEE DETAILS	1 UNIT
I.E) WOODEN LIGHT BOX TABLE	SEE DETAILS	1 LOT
I.F) DISPLAY TABLE - 01	SEE DETAILS	1 UNIT
I.G) DISPLAY TABLE - 02	SEE DETAILS	1 UNIT
I.H) DISPLAY TABLE - 03	SEE DETAILS	1 UNIT
I.I) DISPLAY TABLE - 04	SEE DETAILS	1 UNIT
I.J) DISPLAY TABLE - 05	SEE DETAILS	1 UNIT

II. ELECTRICAL & LIGHTINGS		TOTAL QTY.
II.A) TRACK BAR 2.00M	WHITE CASING	6 UNITS
II.B) TRACK BAR 3.00M	WHITE CASING	4 UNITS
II.C) 20W LED TRACK LIGHT (WARM WHITE)	WHITE CASING	30 PCS.
II.D) CIRCUIT BREAKER - CONTRACTOR TO PROVIDE RATING (1 BREAKER FOR LIGHTING / 1 BREAKER FOR PRODUCTS)		2 UNITS
II.E) 20 WATTS T8 LED TUBE LIGHT		1 UNIT
II.F) 2 GANG CONVENIENCE OUTLET / 2 PRONG CONVENIENCE OUTLET		9 UNITS

III. FURNITURE RENTAL		TOTAL QTY.
III.A) SVENBERTIL CHAIR	SEE DETAILS	4 PCS.
III.B) GAMLARED TABLE	SEE DETAILS	1 PC.
III.C) BROR SHELIVING	SEE DETAILS	1 PC.
III.D) WHITE BAR STOOL WITH BACKREST		2 PCS.

IV. GRAPHICS AND LETTER CUTOUTS		TOTAL QTY.
V.A) DIGITAL PRINT STICKER GRAPHICS ON FOAMBOARD (3.05m x 4.50m)	PAVILION ARCH	2 UNITS
V.B) BACK LIGHTED LETTER CUT-OUT MOUNTED ON WOOD PANEL (0.35m x 2.31m)	PAVILION ARCH	1 UNIT
V.C) DIGITAL PRINT STICKER CUT - OUT (0.40m x 1.30m)	COMPANY NAME	8 UNITS
V.D) DIGITAL PRINT STICKER GRAPHICS (2.10m x 3.20m)	GRID SUPPORT CLADDING	2 UNITS
V.E) DIGITAL PRINT STICKER GRAPHICS ON FOAMBOARD (2.91m x 3.20m)	STORAGE BACKWALL	1 UNIT
V.F) DIGITAL PRINT STICKER GRAPHICS ON FOAMBOARD (3.36m x 3.20m)	CITEM GRAPHICS	1 UNIT
V.G) DIGITAL PRINT STICKER GRAPHICS ON FOAMBOARD (1.50m x 1.00m)	INFO COUNTER	1 UNIT

V. EQUIPMENT, PROPS RENTAL & MANPOWER		TOTAL QTY.
IV.A) MEDIUM SIZE TRASH BIN WITH LID AND GARBAGE BAG (BLACK OR CHROME)		1 PC
IV.B) HOT AND COLD WATER DISPENSER (FLOOR STANDING)		1 UNIT
IV.C) WATER GALLON PER DAY (2 GAL./DAY)		8 GAL.
IV.D) COMMERCIAL COFFEE MAKER (80 TO 100 CUPS)		1 SET
IV.E) PAPER CUPS & STIRRER		600 CUPS/SET
IV.F) COFFEE BAG, CREAMER & SUGAR WITH CONDIMETS ORGANIZER (ANY BRAND)		6 BAGS
IV.G) MANPOWER (Scope of works: Unpacking of crates, Installation of hanging items and wall items, Packing for egress)	1 Electrician and 3 Helper	4 PAX.

		
PROJECT: INDEX DUBAI 2019		
TITLE: PHILIPPINES PAVILION		
LOCATION: DWTC, UAE		
CONTENT: DETAILS	DESIGNER: MIR	
DATE: 08/22/2019	REVISION: 01	SHEET NO: 22