



**PHILIPPINE PAVILION
PERSPECTIVE VIEWS**


Gulfood
2024

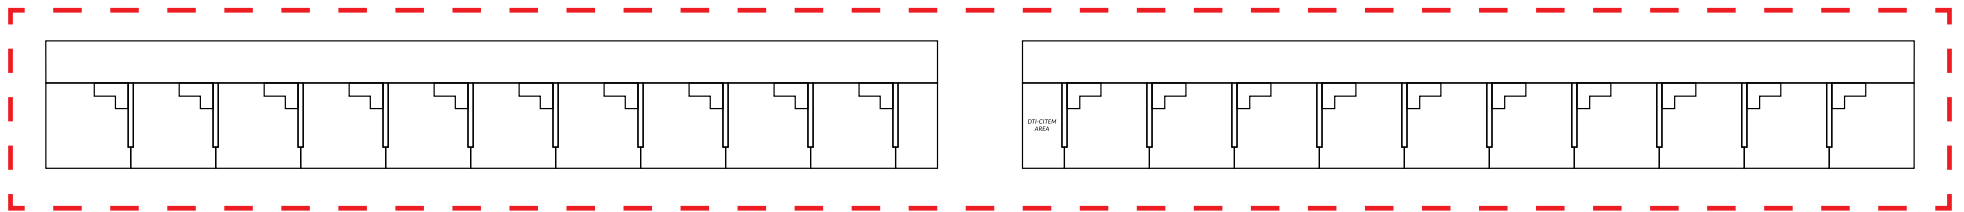

FRONT PERSPECTIVE VIEW

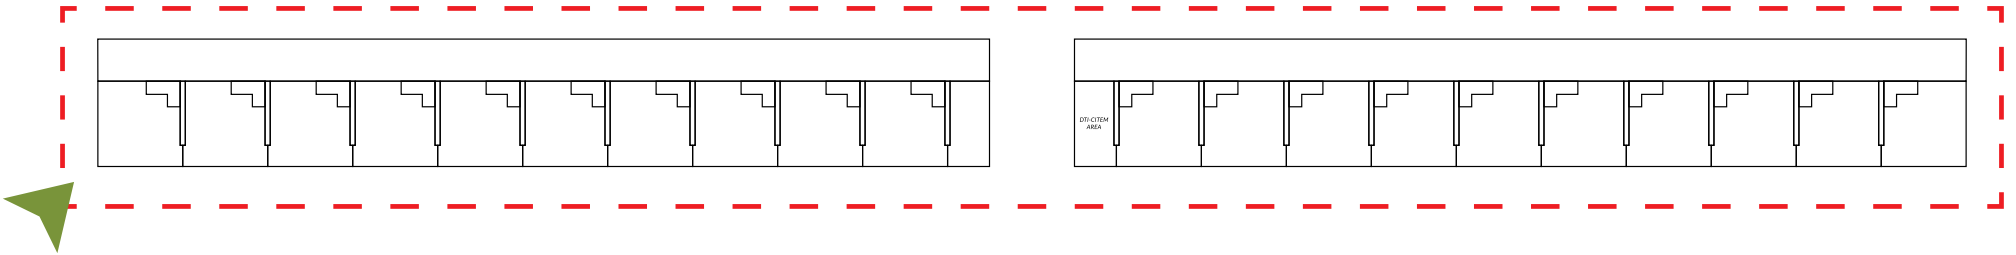

LEFT PERSPECTIVE VIEW

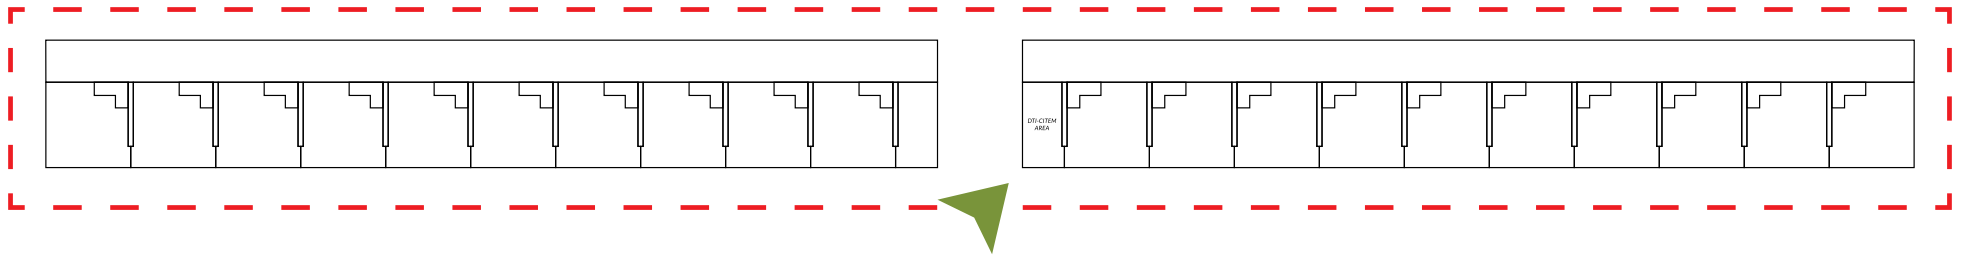

DTI--CITEM AREA



LIGHTED
(embossed)

LIGHTBOX
(lighted, embossed)

**STORAGE ROOM WITH
JAPANESE TYPE
DOOR CURTAIN**

**2 LAYER L-TYPE
SHELVINGS**
(rear product display)

**FRONT DISPLAY SHOWCASE
WITH LOCKABLE STORAGE CABINET**
(option 3)

**BACKLIT COMPANY BOARD/
ARTWORK**
(lighted)

1 TABLE, 2 CHAIRS


PAVILION DETAILS

**PHILIPPINE PAVILION
TECHNICAL DRAWINGS**

Gulfood
2024

Gulfood

DWTC, DUBAI, UAE
19-23 FEBRUARY 2024

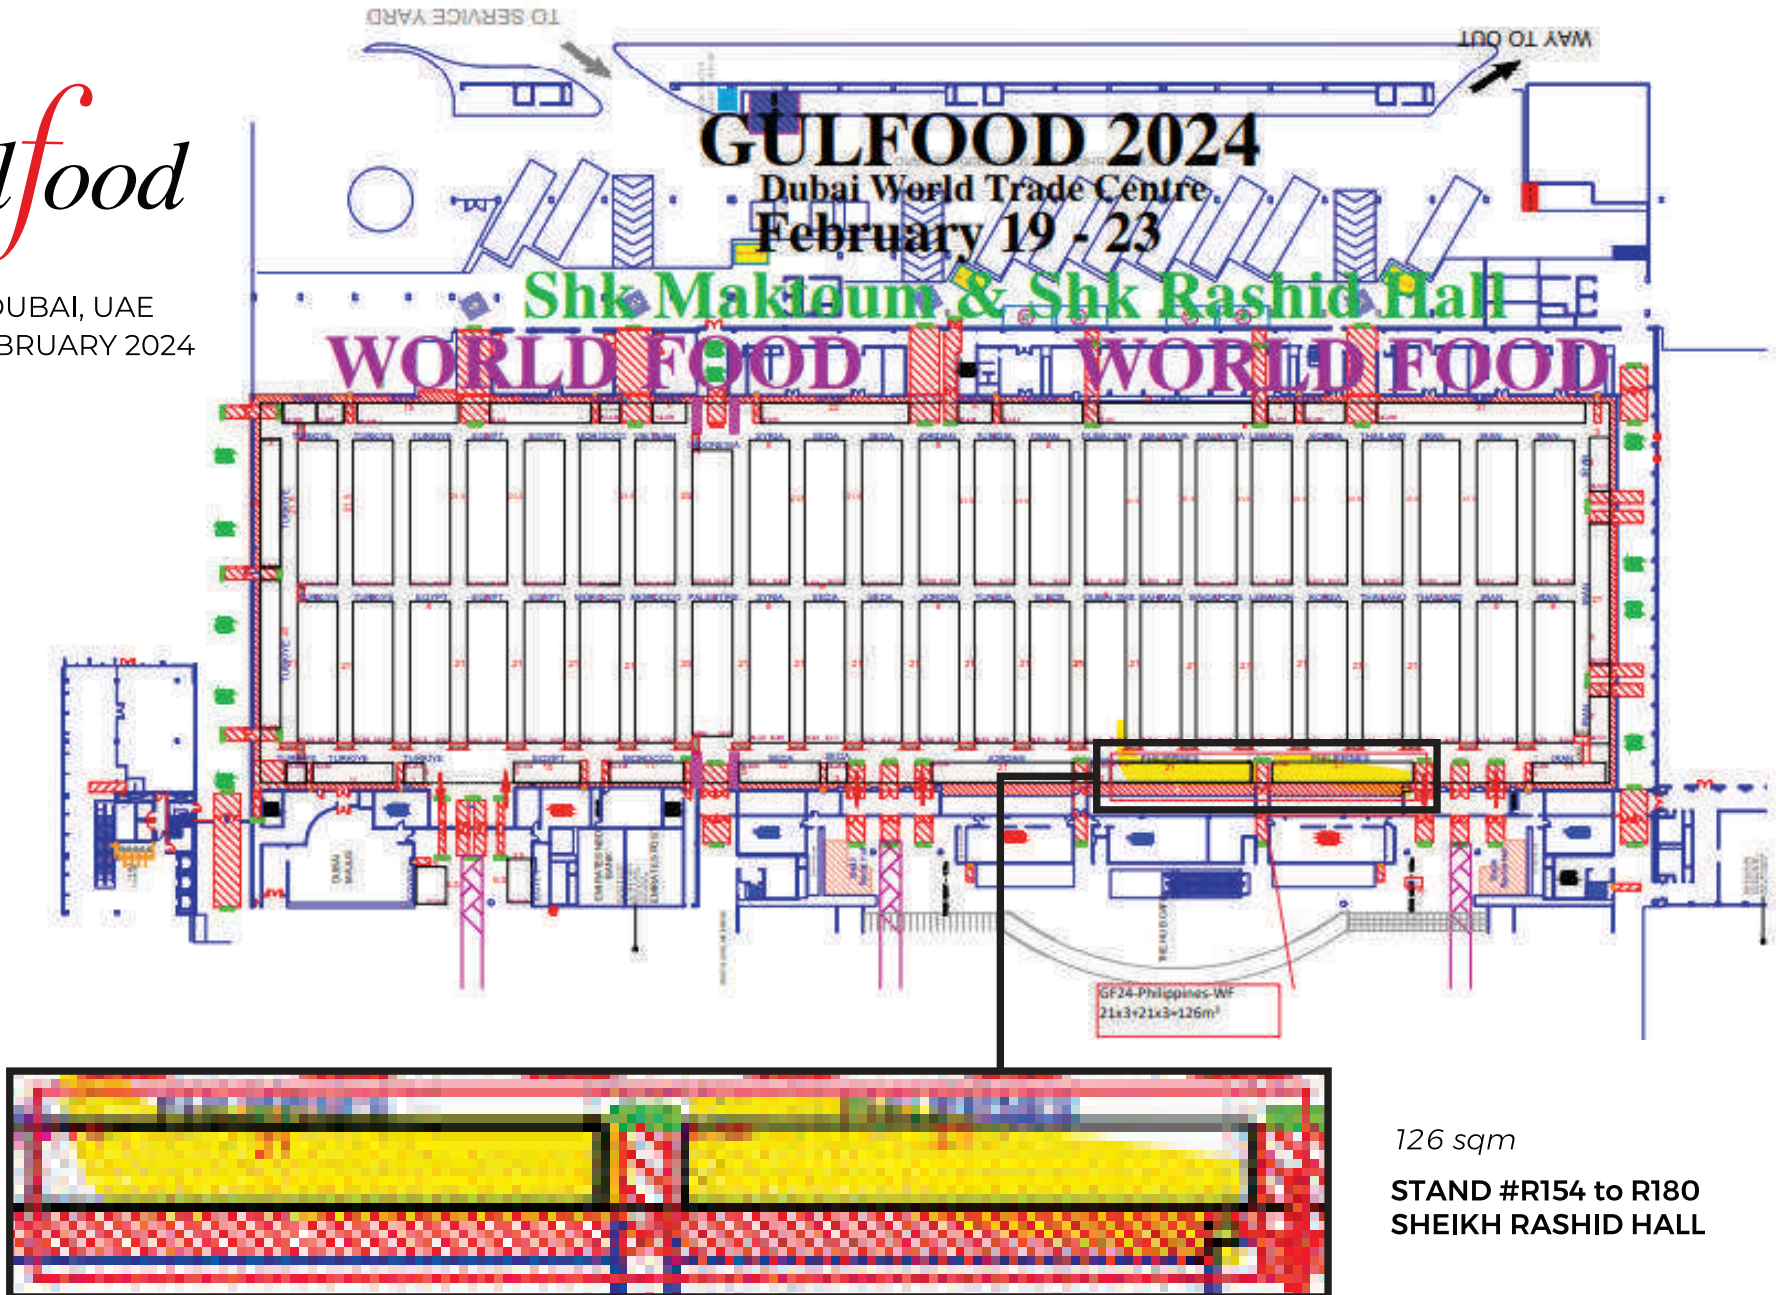

126 sqm



STAND #R154 to R180
SHEIKH RASHID HALL

TECHNICAL DRAWINGS

CITEM STORAGE AREA (1.00m x 1.50m)

see *sheet no.09* for details

STORAGE AREA (2.00m x 1.00m - each exhibitor)

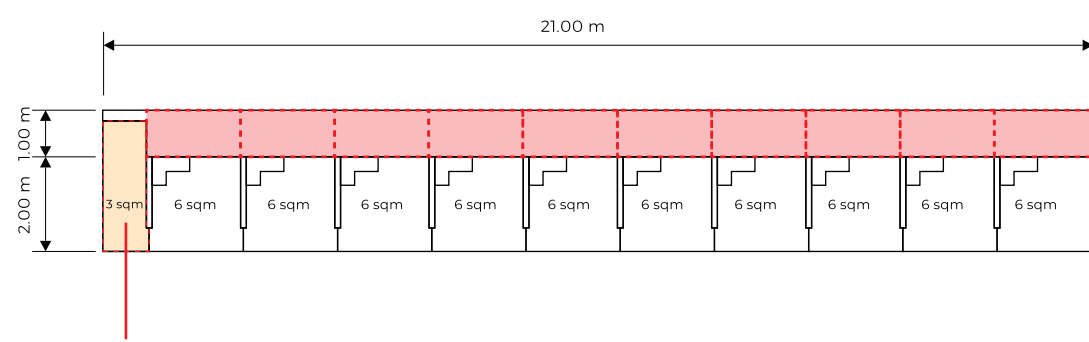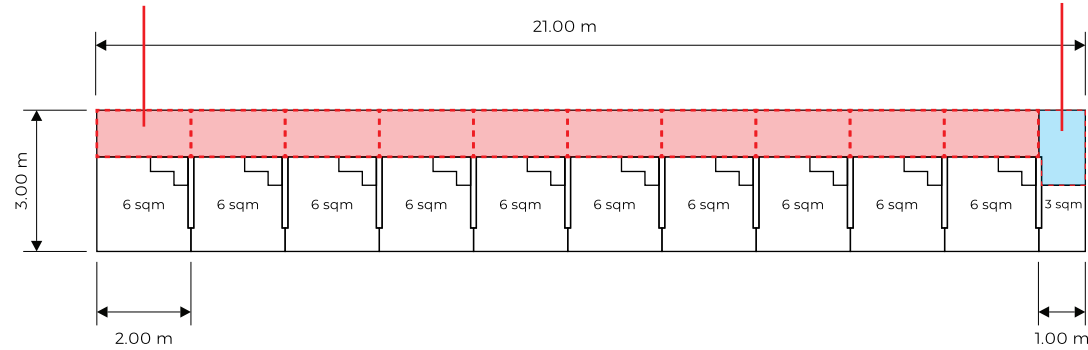

CITEM AREA (1.00m x 2.90m)

see *sheet no.10* for details



TOP VIEW

CARPET FLOORING
*(subject to availability,
as long as near this color)*

LEGEND:


- EXHIBITOR STORAGE AREA
- CITEM STORAGE AREA
- CITEM AREA

FLOOR PLAN

	PROJECT: GULFOOD 2024	
	TITLE: PHILIPPINE PAVILION	
DESIGNED BY: ACGV	LOCATION: DWTC, DUBAI, UAE	
DATE/TIME: 12.20.23	LOCATION: FLOOR PLAN	SHEET NO: 01

TECHNICAL DRAWINGS

TOP VIEW

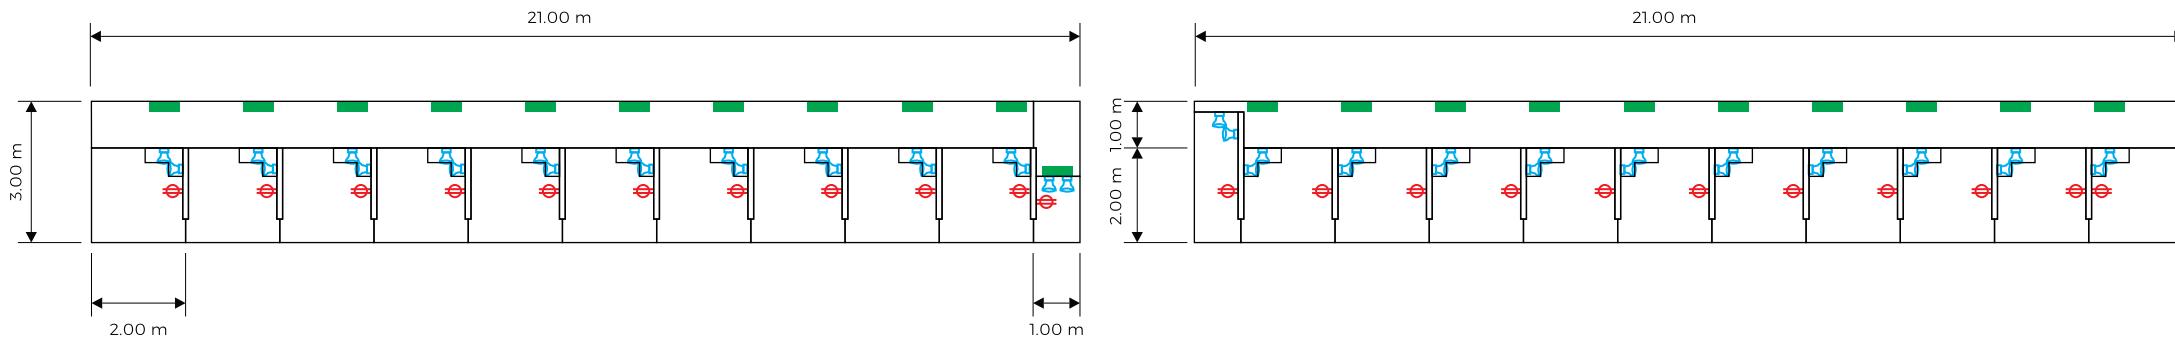

LEGEND:

 TS (INSIDE STORAGE AREA - 21 UNITS)

 SPOTLIGHTS (44 UNITS)

 ELECTRICAL OUTLETS (22 UNITS)

NOTE:

*CONTRACTOR TO PROVIDE APPROPRIATE CIRCUIT BREAKERS AND PROVIDE RATING


*CONTRACTOR TO INCLUDE ELECTRICAL CONSUMPTION IN QUOTATION

LIGHTING & ELECTRICAL PLAN


	PROJECT: GULFOOD 2024	
	TITLE: PHILIPPINE PAVILION	
DESIGNED BY: ACGV	LOCATION: DWTC, DUBAI, UAE	
DATE/TIME: 12.20.23	LOCATION: LIGHTING & ELECTRICAL PLAN	SHEET NO: 02

TECHNICAL DRAWINGS



FRONT VIEW

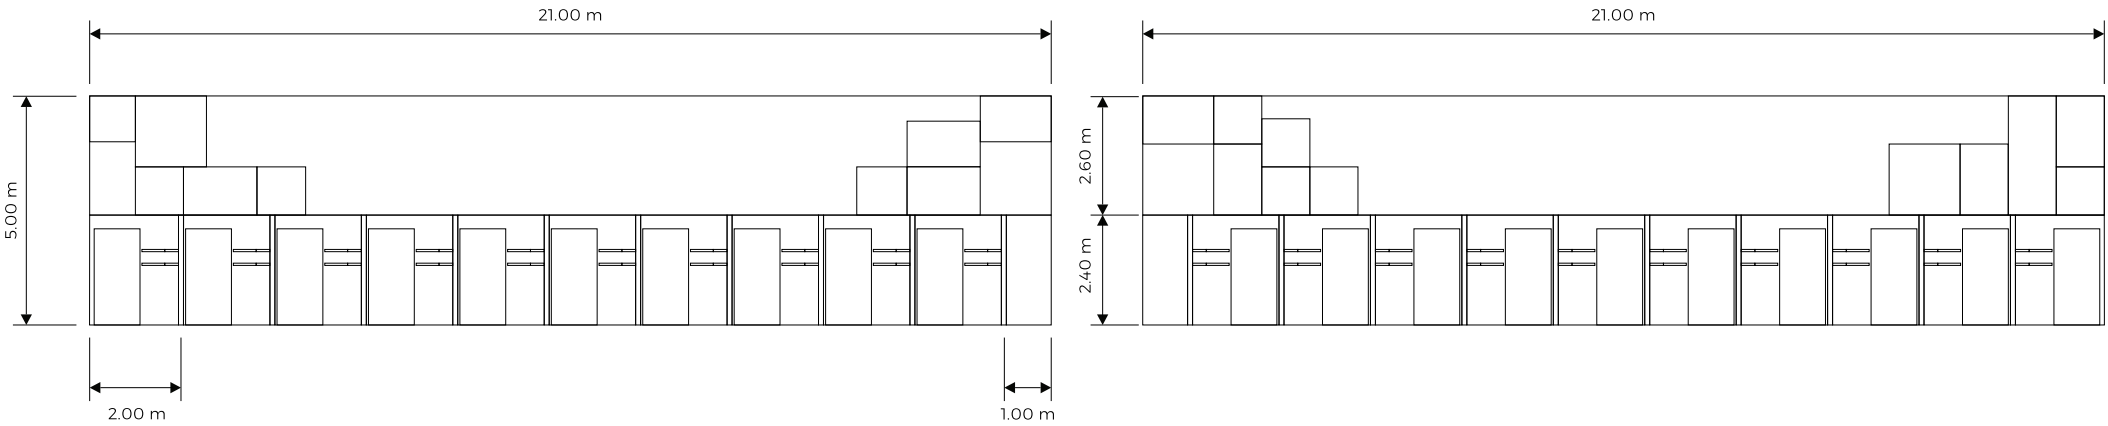

FRONT ELEVATION

	PROJECT:	GULFOOD 2024	
	TITLE:	PHILIPPINE PAVILION	
DESIGNED BY:	LOCATION:	DWTC, DUBAI, UAE	
ACCV			
DATE/TIME:	LOCATION:	ELEVATION	SHEET NO.
12.20.23			03


TECHNICAL DRAWINGS

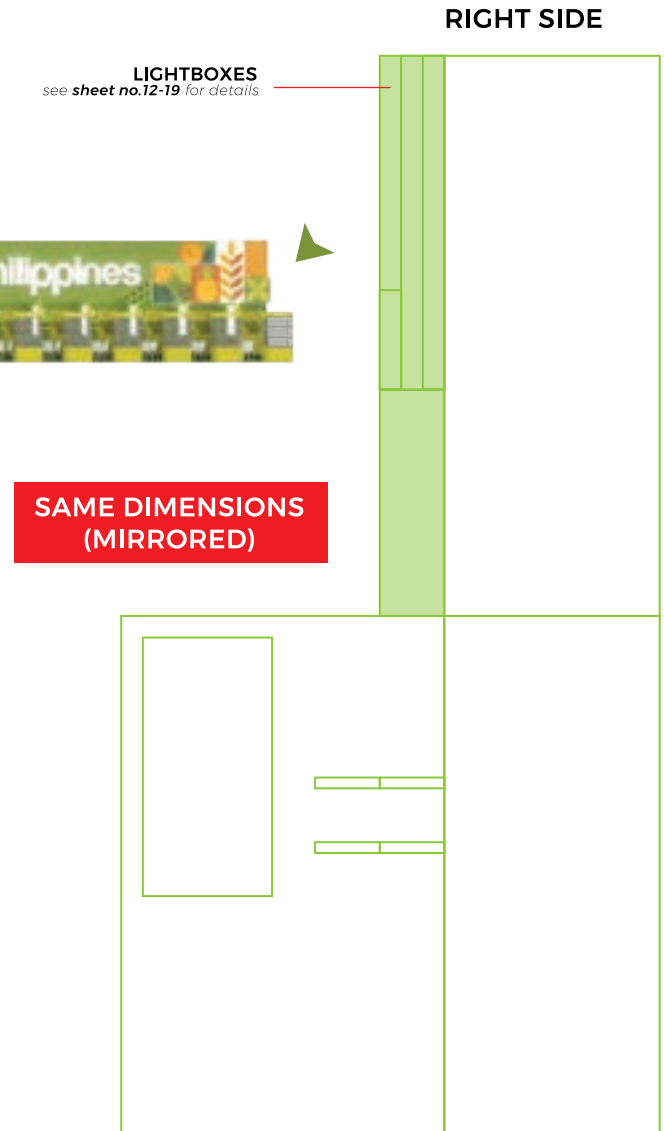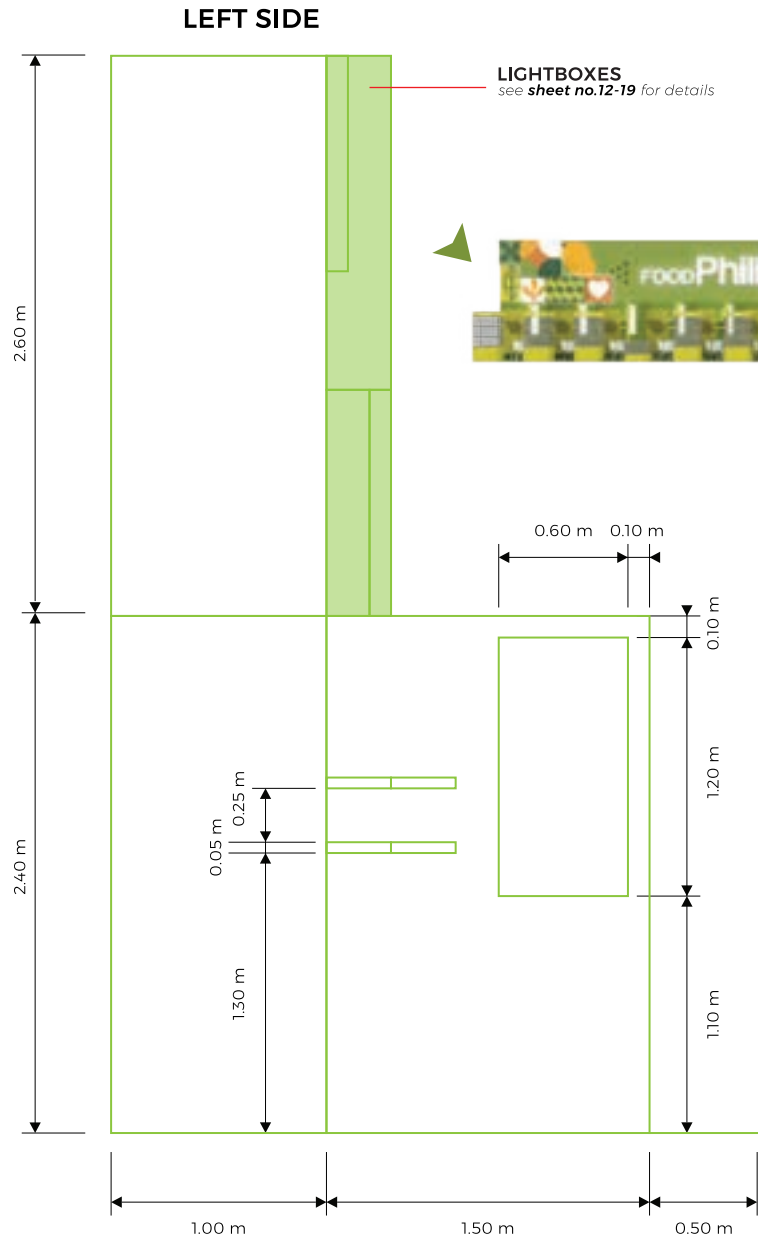

SIDE ELEVATION (EXHIBITOR)

	PROJECT: GULFOOD 2024	
	TITLE: PHILIPPINE PAVILION	
DESIGNED BY: ACGV	LOCATION: DWTC, DUBAI, UAE	
DATE/TIME: 12.20.23	LOCATION: ELEVATION	SHEET NO: 04


TECHNICAL DRAWINGS

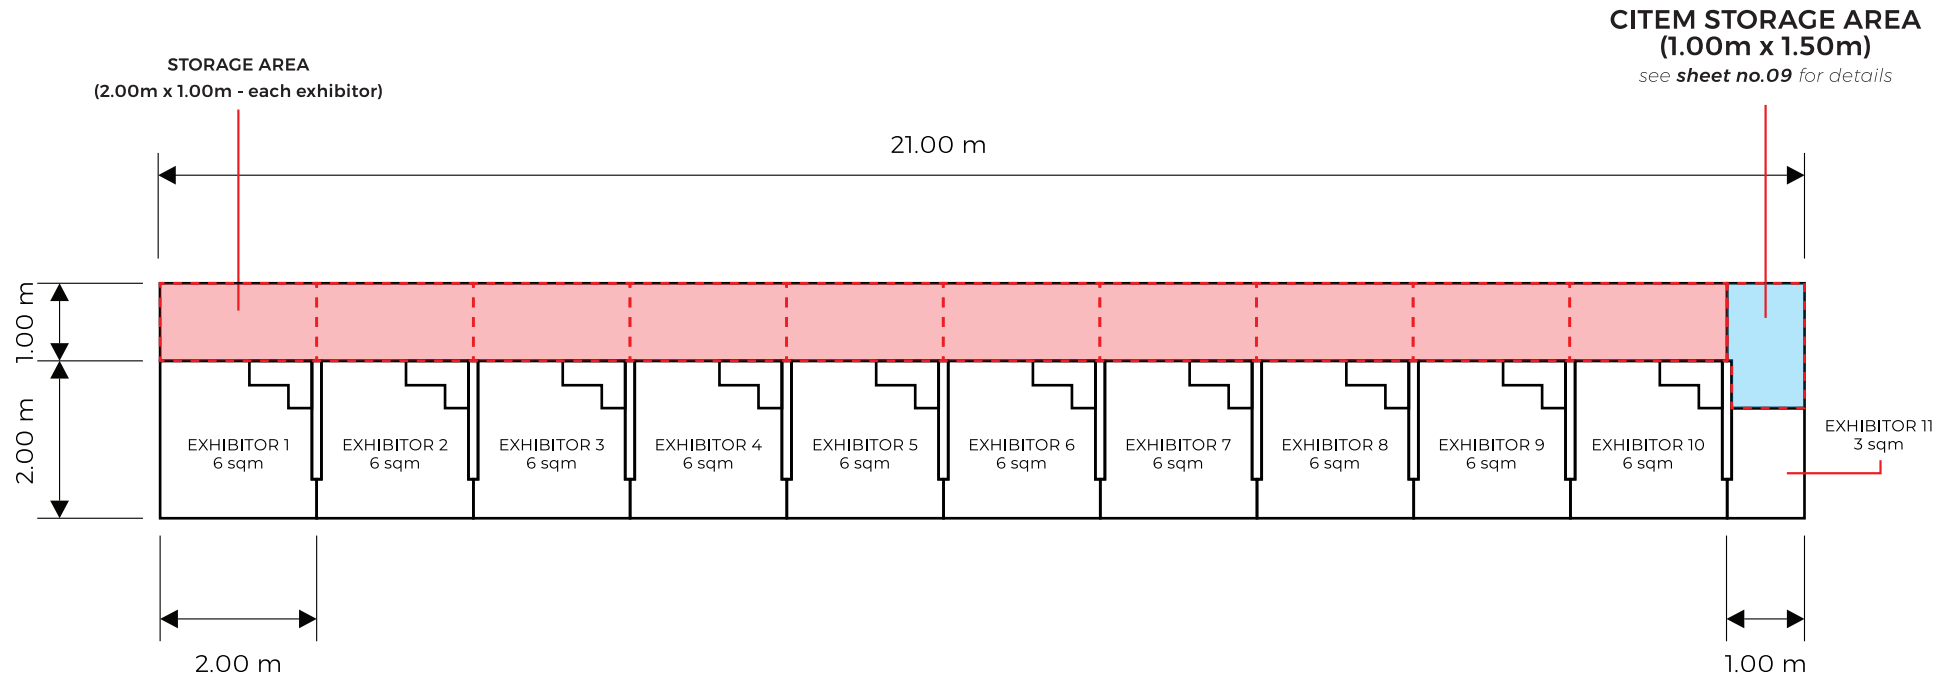

EXHIBITOR LOCATION PLAN (LEFT SIDE)

	PROJECT:	GULFOOD 2024	
	TITLE:	PHILIPPINE PAVILION	
DESIGNED BY:	ACGV	LOCATION:	DWTC, DUBAI, UAE
DATE/TIME:	12.20.23	LOCATION:	LOCATION PLAN
		SHEET NO.:	05





TECHNICAL DRAWINGS

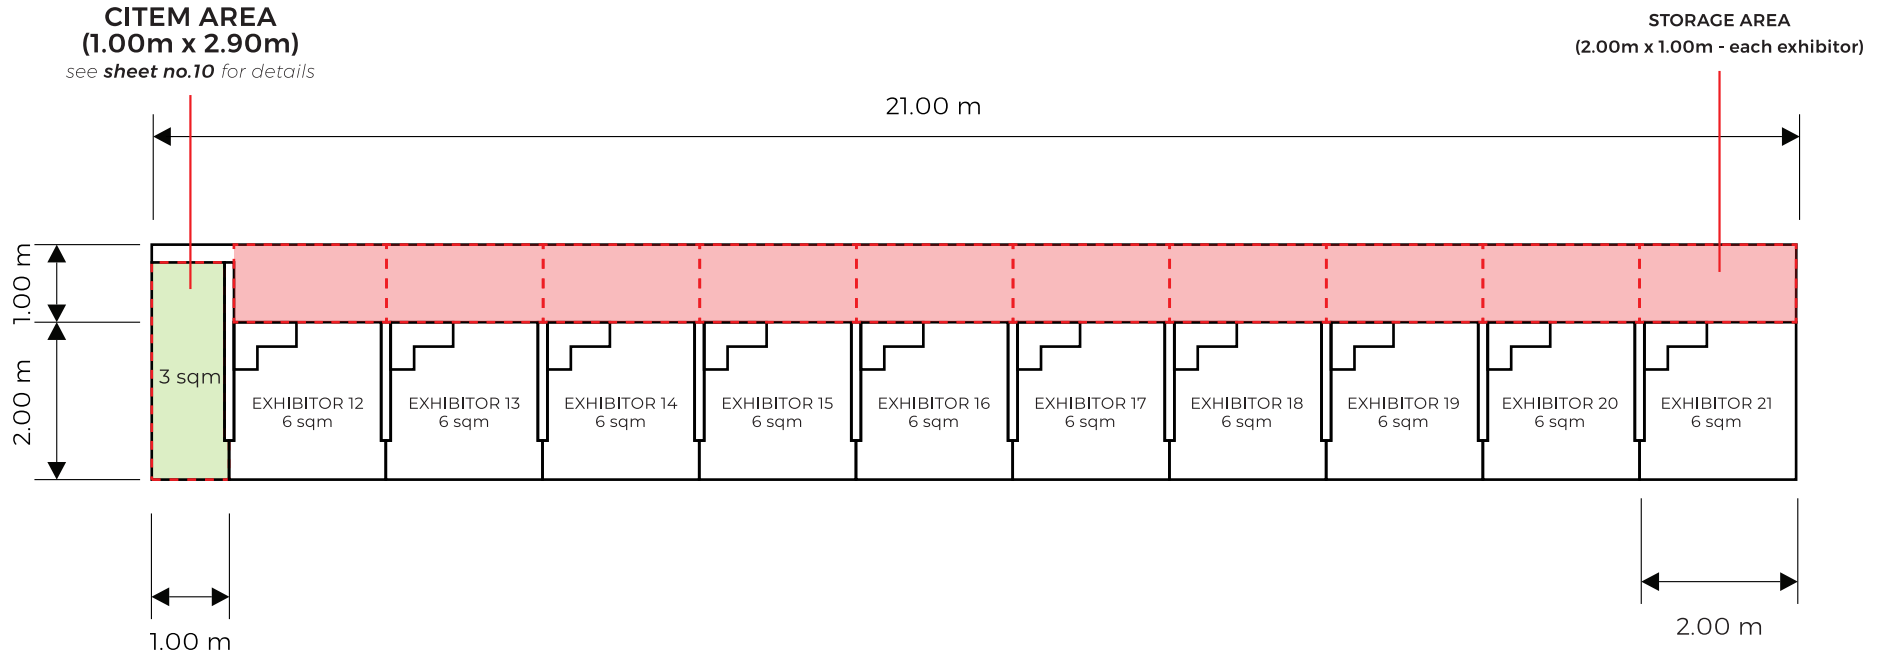



EXHIBITOR LOCATION PLAN (RIGHT SIDE)

	PROJECT:	GULFOOD 2024	
	TITLE:	PHILIPPINE PAVILION	
DESIGNED BY:	ACCV	LOCATION:	DWTC, DUBAI, UAE
DATE/TIME:	12.20.23	LOCATION:	LOCATION PLAN
		SHEET NO.:	06

TECHNICAL DRAWINGS

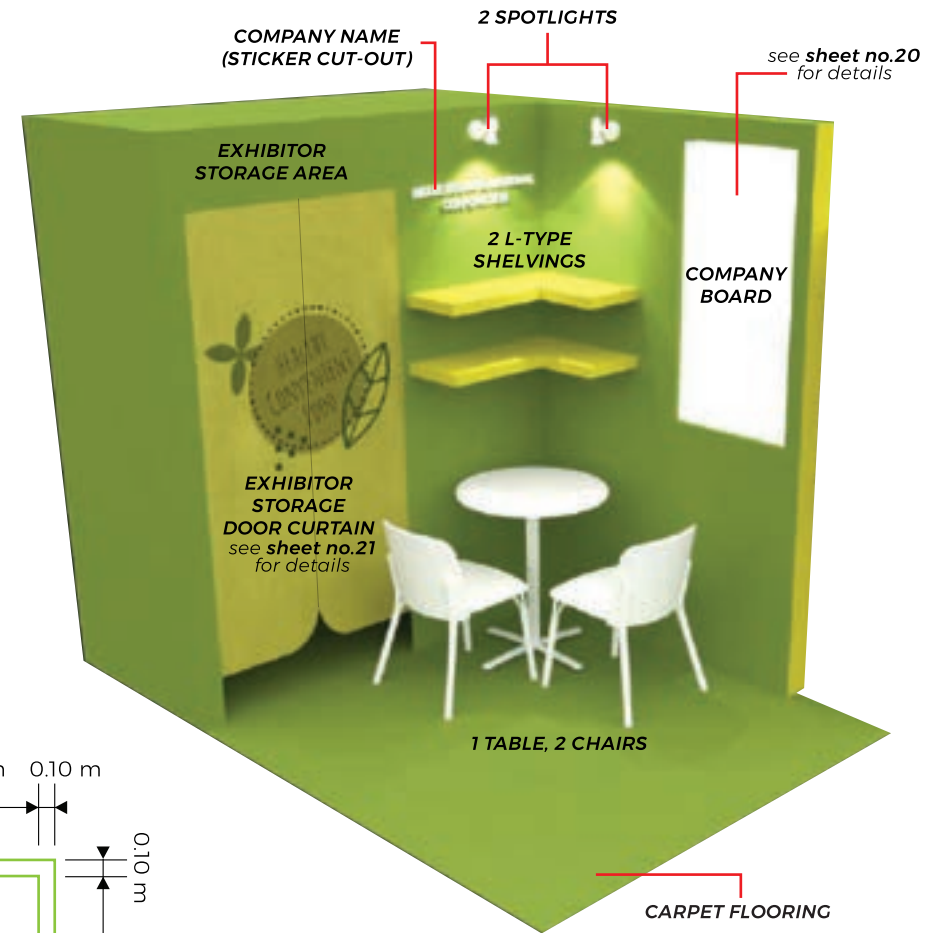
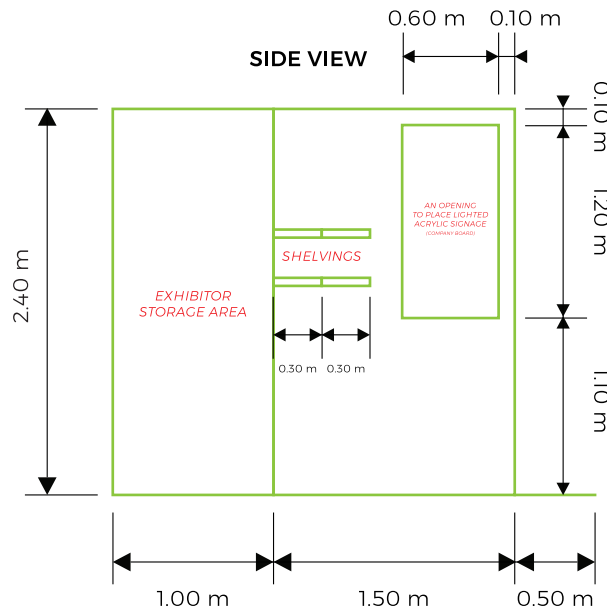
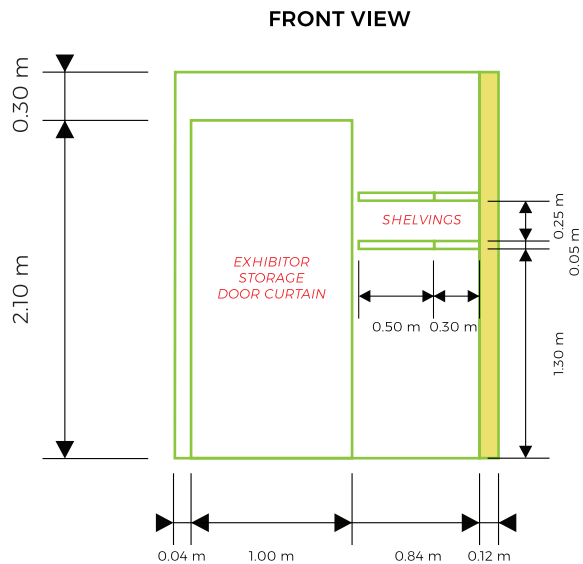
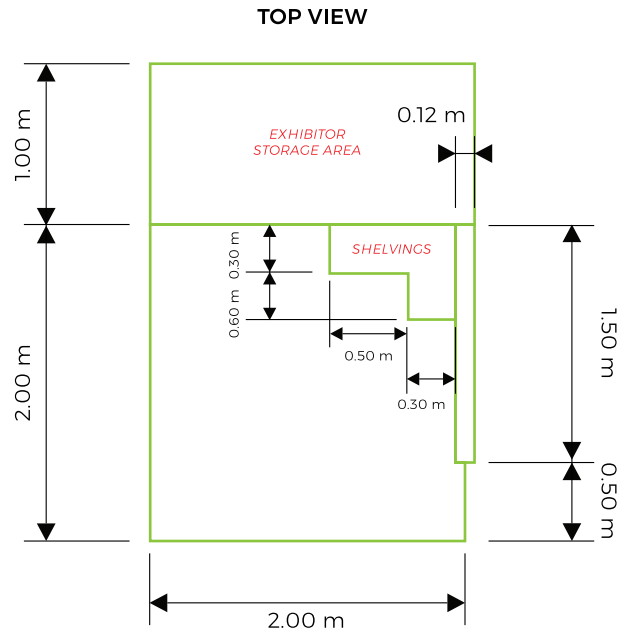


EXHIBITORS 1-10 BOOTH DETAILS

 
 


Citem	PROJECT:	GULFOOD 2024	
	TITLE:	PHILIPPINE PAVILION	
DESIGNED BY:	ACGV	LOCATION:	DWTC, DUBAI, UAE
DATE/TIME:	12.20.23	LOCATION:	BOOTH DETAILS
			SHEET NO: 07

TECHNICAL DRAWINGS

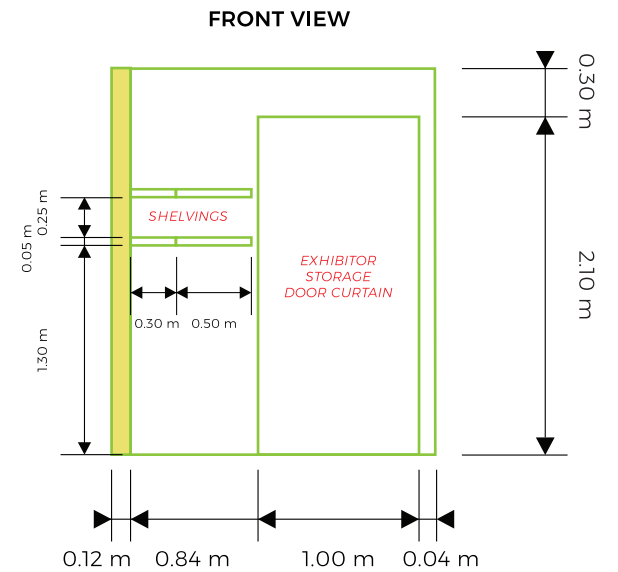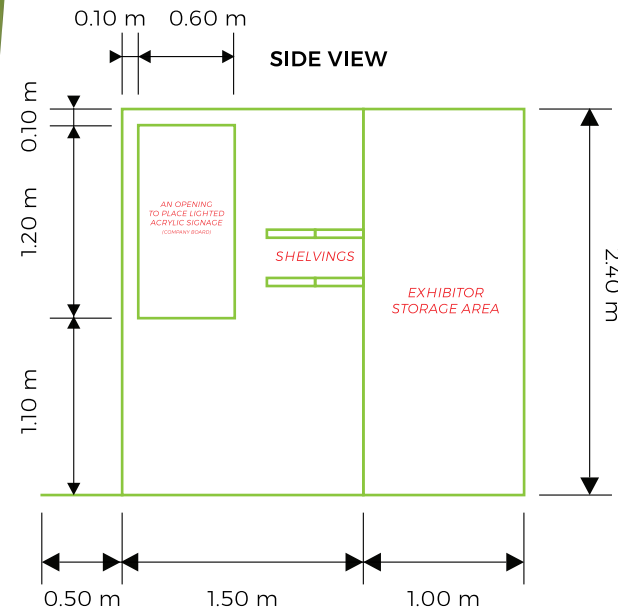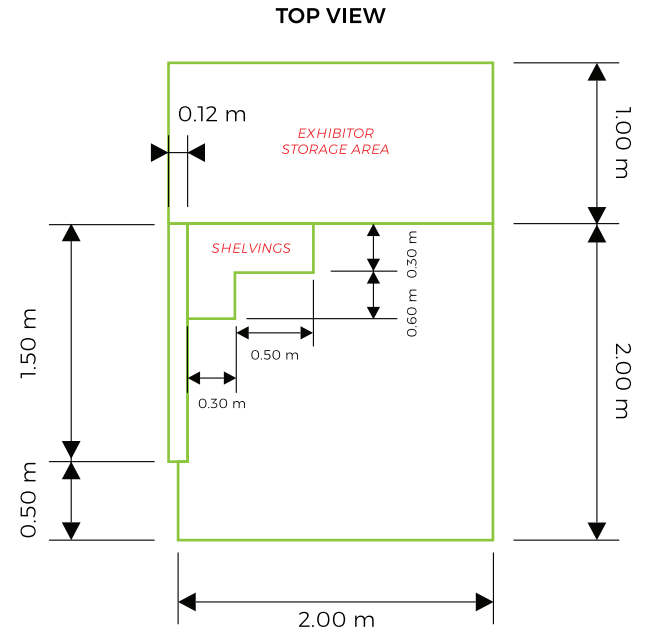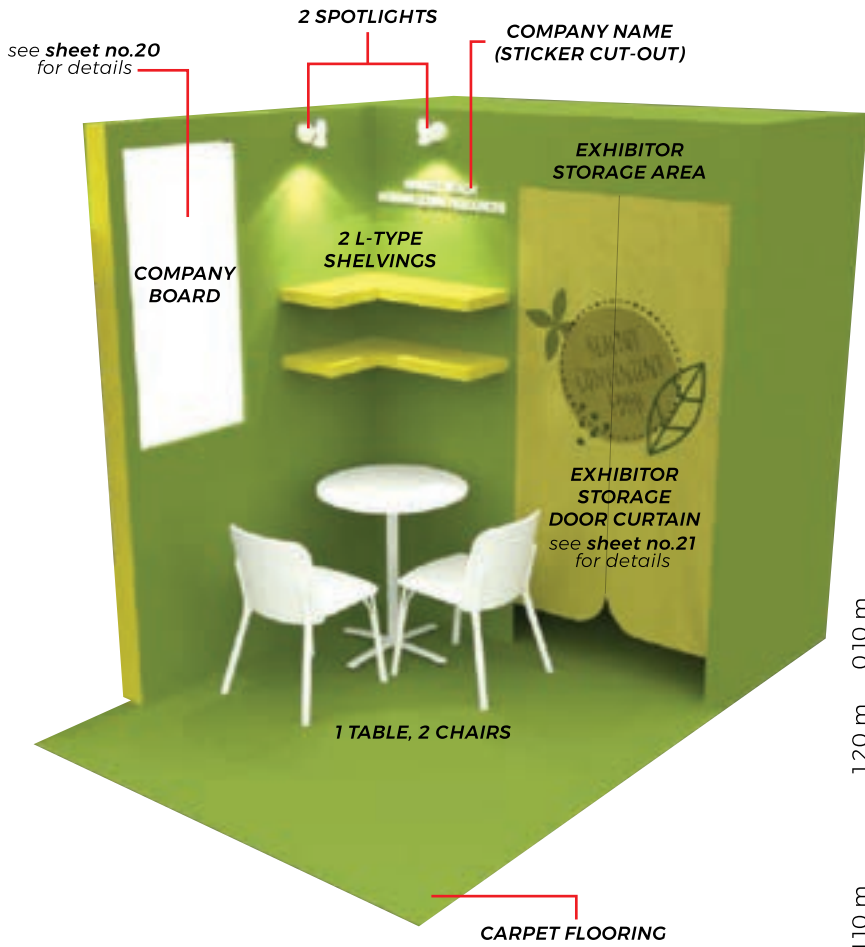

EXHIBITORS 12-21 BOOTH DETAILS

  

Citem	PROJECT:	GULFOOD 2024	
	TITLE:	PHILIPPINE PAVILION	
DESIGNED BY:	ACCV	LOCATION:	DWTC, DUBAI, UAE
DATE/TIME:	12.20.23	LOCATION:	BOOTH DETAILS
			SHEET NO: 08